



PhilGEPS

Philippine Government Electronic Procurement System

Central Portal for
Philippine Government
Procurement Opportunities

Bid Notice Abstract

107

Invitation to Bid (ITB)

Reference Number 8782472
Procuring Entity CARLOS HILADO MEMORIAL STATE UNIVERSITY
Title Installation of Convenience Outlets and Conversion of Ceiling Light to LED Light in the Lecture Rooms and Laboratory Rooms (Labor and Materials) - Talisay Campus
Area of Delivery Negros Occidental

Solicitation Number:	CHMSC 22-028-0623-I	Status	Pending
Trade Agreement:	Implementing Rules and Regulations	Associated Components	7
Procurement Mode:	Public Bidding	Bid Supplements	0
Classification:	Civil Works	Document Request List	0
Category:	Construction Projects	Date Published	24/06/2022
Approved Budget for the Contract:	PHP 1,841,380.00	Last Updated / Time	23/06/2022 16:37 PM
Delivery Period:	60 Day/s	Closing Date / Time	14/07/2022 10:00 AM
Client Agency:			
Contact Person:	Ma. Lorena Fernandez Jugos Administrative Assistant II Mabini Street, Brgy Zone 1 Talisay City Negros Occidental Philippines 6115 63-34-7128404 63-34-7128404 chmsc_bacsec@yahoo.com		

Description

CARLOS HILADO MEMORIAL STATE UNIVERSITY
BIDS AND AWARDS COMMITTEE
TALISAY CITY, NEGROS OCCIDENTAL

INVITATION TO BID
FOR THE INSTALLATION OF CONVENIENCE OUTLETS AND CONVERSION OF CEILING LIGHT TO LED LIGHT IN THE LECTURE ROOMS AND LABORATORY ROOMS (LABOR AND MATERIALS) – TALISAY CAMPUS
CHMSC 22-028-0623-I

1. The Carlos Hilado Memorial State University, through the Corporate Budget for the Contract of 2022 approved by the governing Board (MDS), intends to apply the sum of ONE MILLION EIGHT HUNDRED FORTY-ONE THOUSAND THREE HUNDRED EIGHTY PESOS & 00/100 (Php 1,841,380.00) ONLY being the Approved Budget for the Contract (ABC) to payments under the contract for the INSTALLATION OF CONVENIENCE OUTLETS AND CONVERSION OF CEILING LIGHT TO LED LIGHT IN THE LECTURE ROOMS AND LABORATORY ROOMS (LABOR AND MATERIALS) – TALISAY CAMPUS. Bids received in excess of the ABC shall be automatically rejected at bid opening.
2. The Carlos Hilado Memorial State University now invites bids for the above Procurement Project. Completion of the Works is required within Sixty (60) calendar days upon receipt of Notice to Proceed. Bidders should have completed a contract similar to the Project. The description of an eligible bidder is contained in the Bidding Documents, particularly, in Section II (Instructions to Bidders).
3. Bidding will be conducted through open competitive bidding procedures using the non-discretionary "pass/fail" criterion as specified in the 2016 revised Implementing Rules and Regulations (IRR) of Republic Act (RA) No. 9184.
4. Interested bidders may obtain further information from CARLOS HILADO MEMORIAL STATE UNIVERSITY and

inspect the Bidding Documents at the address given below from 8:00 A.M. to 5:00 P.M.

5. A complete set of Bidding Documents may be acquired by interested bidders on June 24 – July 14, 2022 (9:30 A.M.) from given address and website/s below and upon payment of the applicable fee for the Bidding Documents, pursuant to the latest Guidelines issued by the GPPB, in the amount of Five Thousand Pesos (Php 5,000.00) Only. The Procuring Entity shall allow the bidder to present its proof of payment for the fees.

6. The CHMSU will hold a Pre-Bid conference on 10:30 A.M., July 1, 2022 at Bidding Room, 2/F Supply and Property Management Bldg., Brgy. Zone 1, Mabini St., Talisay City, Negros Occidental and or through video conferencing or webcasting via Zoom Meeting with ID No. 797 389 7583, Meeting Password 070122, which shall be open to prospective bidders.

7. Bids must be duly received by the BAC Secretariat through (i) manual submission at the office address as indicated below, (ii) online or electronic submission as indicated below, or (iii) both on or before 10:00 A.M., July 14, 2022. Late bids shall not be accepted.

Bids may be submitted through electronic mail to bac.sec@chmsc.edu.ph provided that the bidding documents are compressed into two (2) separate archived folders (zip or rar format) and which each folder shall be labelled as "First Envelope_Name of Company_Project Reference Number" and "Second Envelope_Name of Company_Project Reference Number" and each is uniquely password-protected;

Bidders must submit the printed copies (Original, Copy 1 and Copy 2) of their bidding documents within 3 calendar days from bid opening.

8. All Bids must be accompanied by a bid security in any of the acceptable forms and in the amount stated in ITB Clause 16.

9. Bid opening shall be on 10:30 A.M., July 14, 2022 at the Bidding Room, 2/F Supply and Property Management Bldg., Brgy. Zone 1, Mabini St., Talisay City, Negros Occidental and/or through Zoom Meeting ID No. 797 389 7583, Meeting Password 071422. Bids will be opened in the presence of the bidders' representatives who choose to attend the activity.

10. The Carlos Hilado Memorial State University reserves the right to reject any and all bids, declare a failure of bidding, or not award the contract at any time prior to contract award in accordance with Sections 35.6 and 41 of the 2016 revised Implementing Rules and Regulations (IRR) of RA No. 9184, without thereby incurring any liability to the affected bidder or bidders.

11. For further information, please refer to:

MISS LIGAYA E. FUENTES
Head, BAC Secretariat
Carlos Hilado Memorial State University
Bidding Room, 2/F Supply and Property Management Bldg.
Brgy. Zone 1, Mabini St.,
Talisay City, Negros Occidental
Email Add.: bac.sec@chmsc.edu.ph
Telefax No. (034) 712-0003 local 142
Website: chmsc.edu.ph

12. You may visit the following websites:

For downloading of Bidding Documents: chmsc.edu.ph

For online bid submission: bac.sec@chmsc.edu.ph


ENGR. JUN JUN J. MARQUEZ
BAC Chairperson

Line Items


Item No.	Product/Service Name	Description	Quantity	UOM	Budget (PHP)
1	ONE (1) LOT	Installation of Convenience Outlets and Conversion of Ceiling Light to LED Light in the Lecture Room and Laboratory Room (Labor and Materials) - Talisay Campus	1	Lot	1,841,380.00

Pre-bid Conference

Date	Time	Venue
01/07/2022	10:30:00 AM	Bidding Room, 2/F Supply and Property Management Bldg., Brgy. Zone 1, Mabini St., Talisay City, Negros Occidental and or through video conferencing or webcasting

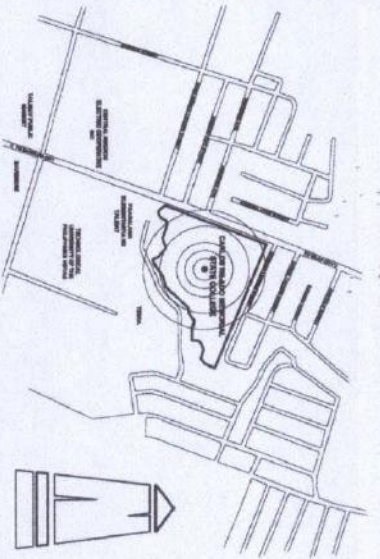

VICINITY MAP
SCALE
NDTS

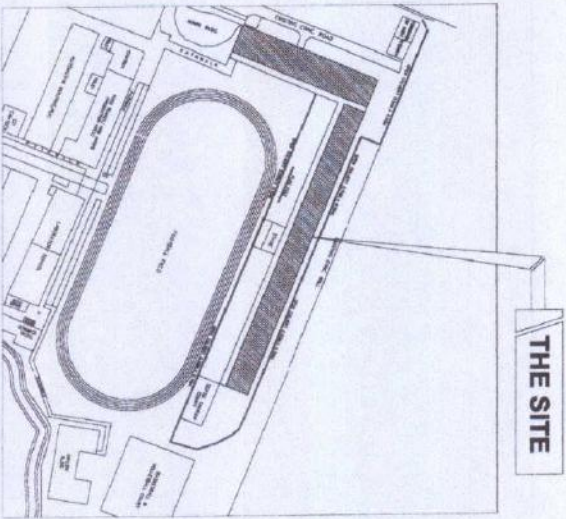

SITE DEVELOPMENT MAP
SCALE
NDTS

LIST OF ROOMS :


- | | | | |
|--------------------------|--------------------------|-------------------------|--------------------------|
| GROUND FLOOR PLAN | SECOND FLOOR PLAN | THIRD FLOOR PLAN | FOURTH FLOOR PLAN |
| ROOM 103 | ROOM 211 | ROOM 311 | ROOM 402 |
| ROOM 104 | ROOM 212 | ROOM 312 | ROOM 403 |
| ROOM 105 | ROOM 213 | ROOM 313 | ROOM 404 |
| ROOM 106 | ROOM 214 | ROOM 314 | ROOM 405 |
| ROOM 107 | ROOM 221 | ROOM 321 | ROOM 406 |
| | ROOM 222 | ROOM 322 | ROOM 410 |
| | | | ROOM 411 |
| | | | ROOM 412 |
| | | | ROOM 413 |






PERSPECTIVE DRAWING
SCALE
NDTS

<p>Republic of the Philippines OFFICE OF THE NATIONAL CENTER FOR PHYSICAL PLANNING AND MANAGEMENT</p>		<p>PROJECT TITLE: PROPOSED INSTALLATION OF CONVENIENCE OUTLETS AND CONVERSION OF CEILING LIGHT LABORATORY ROOM</p>		<p>PREPARED BY: ARNEL R. LATURNAS COLLEGE DEPUTY MANAGER</p>		<p>CHECKED BY: ALBERTO S. TORRES, MPA, CEMP ENRICO S. CHAVAZO JR. DIRECTOR FPDA</p>		<p>APPROVED BY: ROSALEONDA S. TUVILLA, LIS VICE PRESIDENT FOR ADMINISTRATION</p>		<p>SHEET NO.: A</p>	
		<p>PROJECT LOCATION: ILAGAN CAMPUS</p>						<p>NOBBERTO P. MANGUJUANAN, Ph.D. DIR. PRESIDENT III</p>		<p>PAGE NO.: 1</p>	

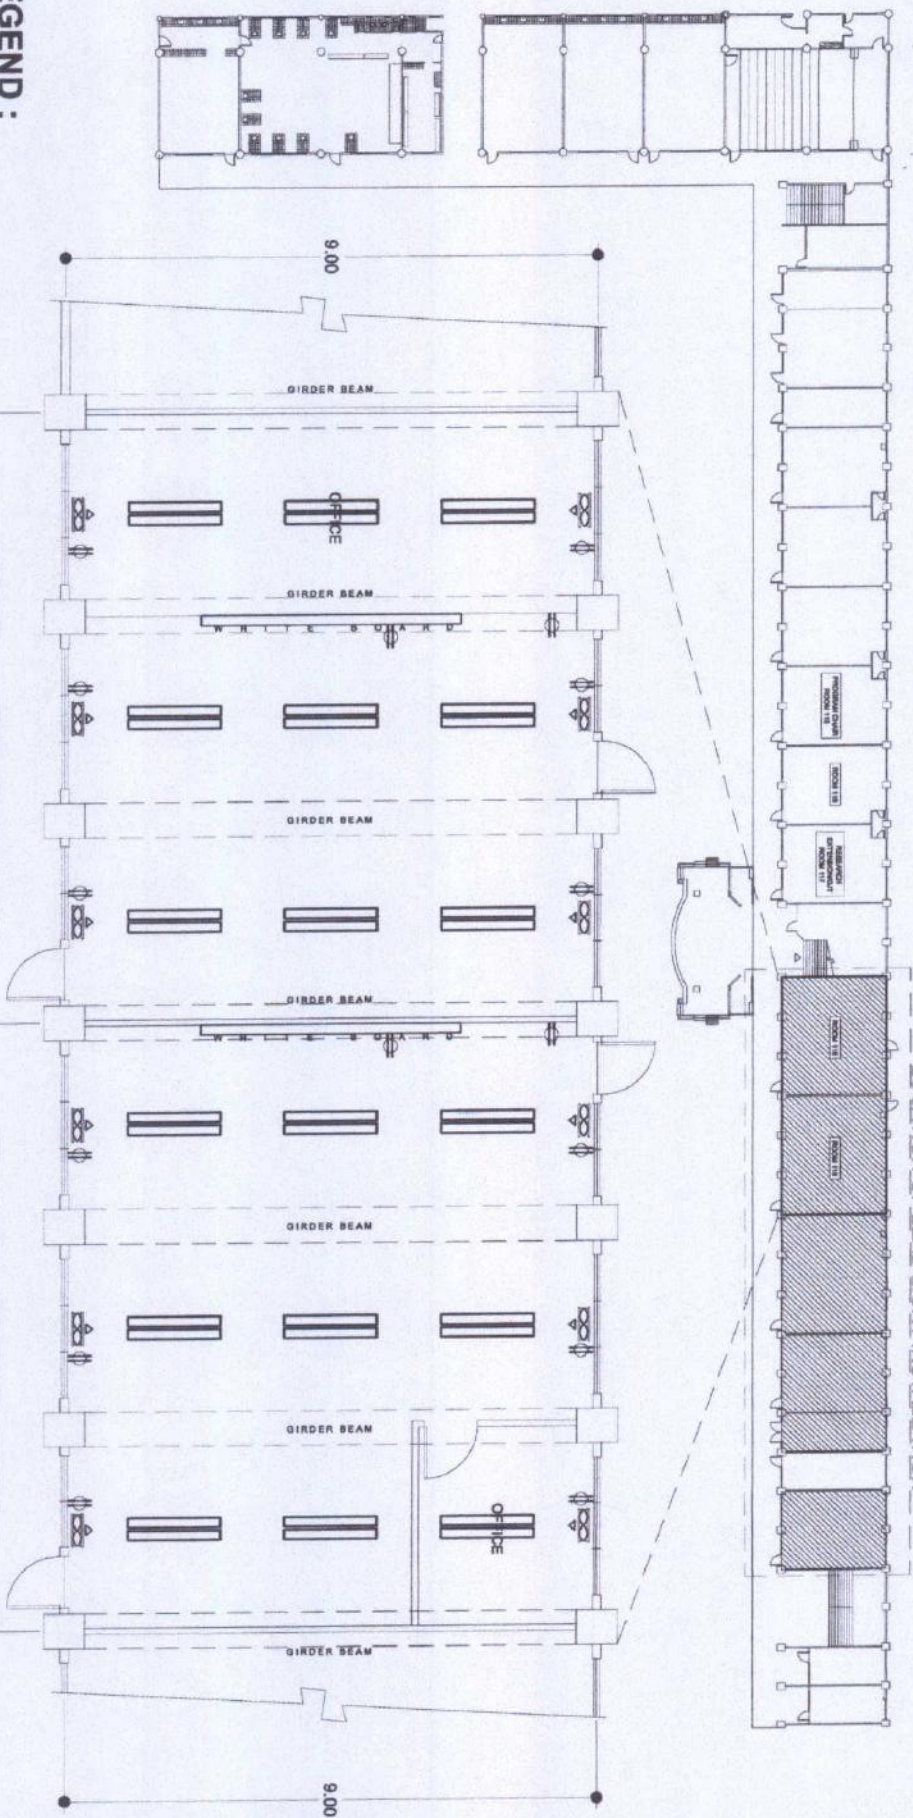
LOCATION OF LEAD LIGHT INSTALLATION

 


LEGEND :



-  WALL FAN
-  ADDITIONAL OUTLET
-  DOUBLE T8 TUBE LEAD LIGHT

LSA BUILDING GROUND FLOOR PLAN
SCALE 1:100M

 <p>Republic of the Philippines DEPARTMENT OF EDUCATION PHILIPPINE COUNCIL ON HIGHER EDUCATION 1001 Alabang Village, Muntinlupa City, Metro Manila</p>		<p>PROJECT TITLE: PROPOSED CONVERSION OF LECTURE ROOMS TO NEW CLASSROOM SETTING - ELECTRICAL WORKS (PHASE 2)</p>		<p>PREPARED BY: ANNIE E. LATUJINAS COLLEGE DRAFTER</p>		<p>CHECKED BY: ALBERT S. SORIANO, JR. COLLEGE ENGINEER</p>		<p>APPROVED BY: NORBERTO P. MANGULABANAN, Ph.D. SUC PRESIDENT III</p>		<p>SHEET NO. A</p>	
<p>PROJECT LOCATION: TALENT CAMPUS</p>		<p>DATE: 11/11/2014</p>		<p>DATE: 11/11/2014</p>		<p>DATE: 11/11/2014</p>		<p>DATE: 11/11/2014</p>		<p>PAGE NO. 3</p>	

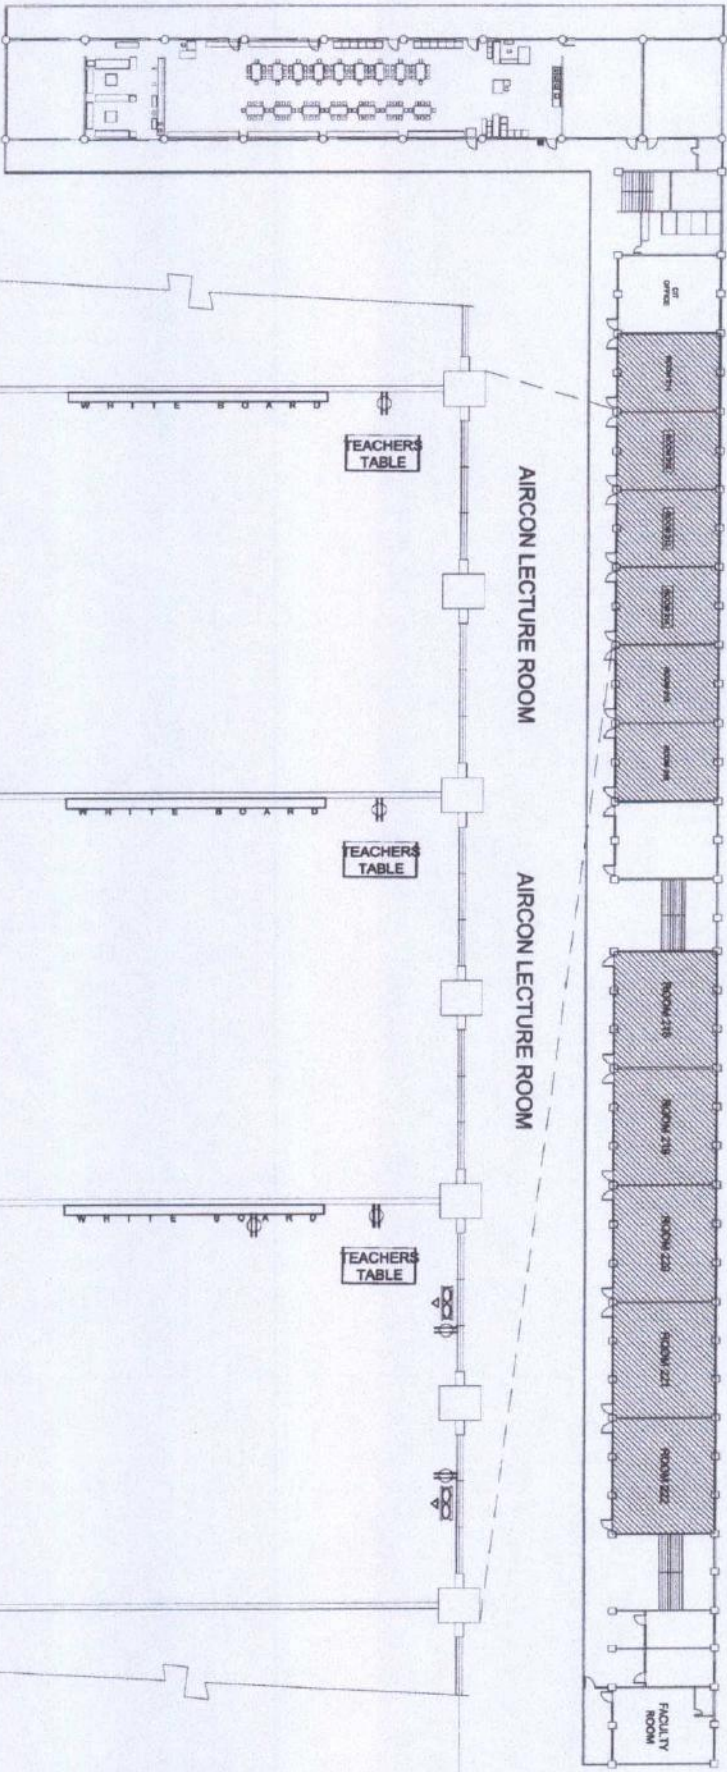


LEGEND :

  WALL FAN
 ADDITIONAL OUTLET




LSA BUILDING SECOND FLOOR PLAN
SCALE 1:100M

 Republic of the Philippines DEPARTMENT OF EDUCATION OFFICE OF THE ASSISTANT SECRETARY FOR COLLEGE EDUCATION		PROJECT TITLE: PROPOSED CONVERSION OF LECTURE ROOMS TO NEW CLASSROOM SETTINGS - ELECTRICAL WORKS (PHASE 2) PROJECT LOCATION: VALAYAN CAMPUS		PREPARED BY: ANIEL E. LATUBINAS COLLEGE ENGINEER		CHECKED BY: ALAN... COLLEGE ENGINEER		DESIGNED BY: ROSALINDA... VICE PRESIDENT FOR ADMINISTRATION		APPROVED BY: NOBERTO... SPC RESIDENT		SHEET NO.: A		PAGE NO.: 4	
----------------------------------------------------------------------------------------------------------------------------------------------------------------------------------------------------------	--	----------------------------------------------------------------------------------------------------------------------------------------------------------	--	---------------------------------------------------------------	--	---------------------------------------------------	--	--------------------------------------------------------------------------	--	---------------------------------------------------	--	-------------------------------	--	------------------------------	--

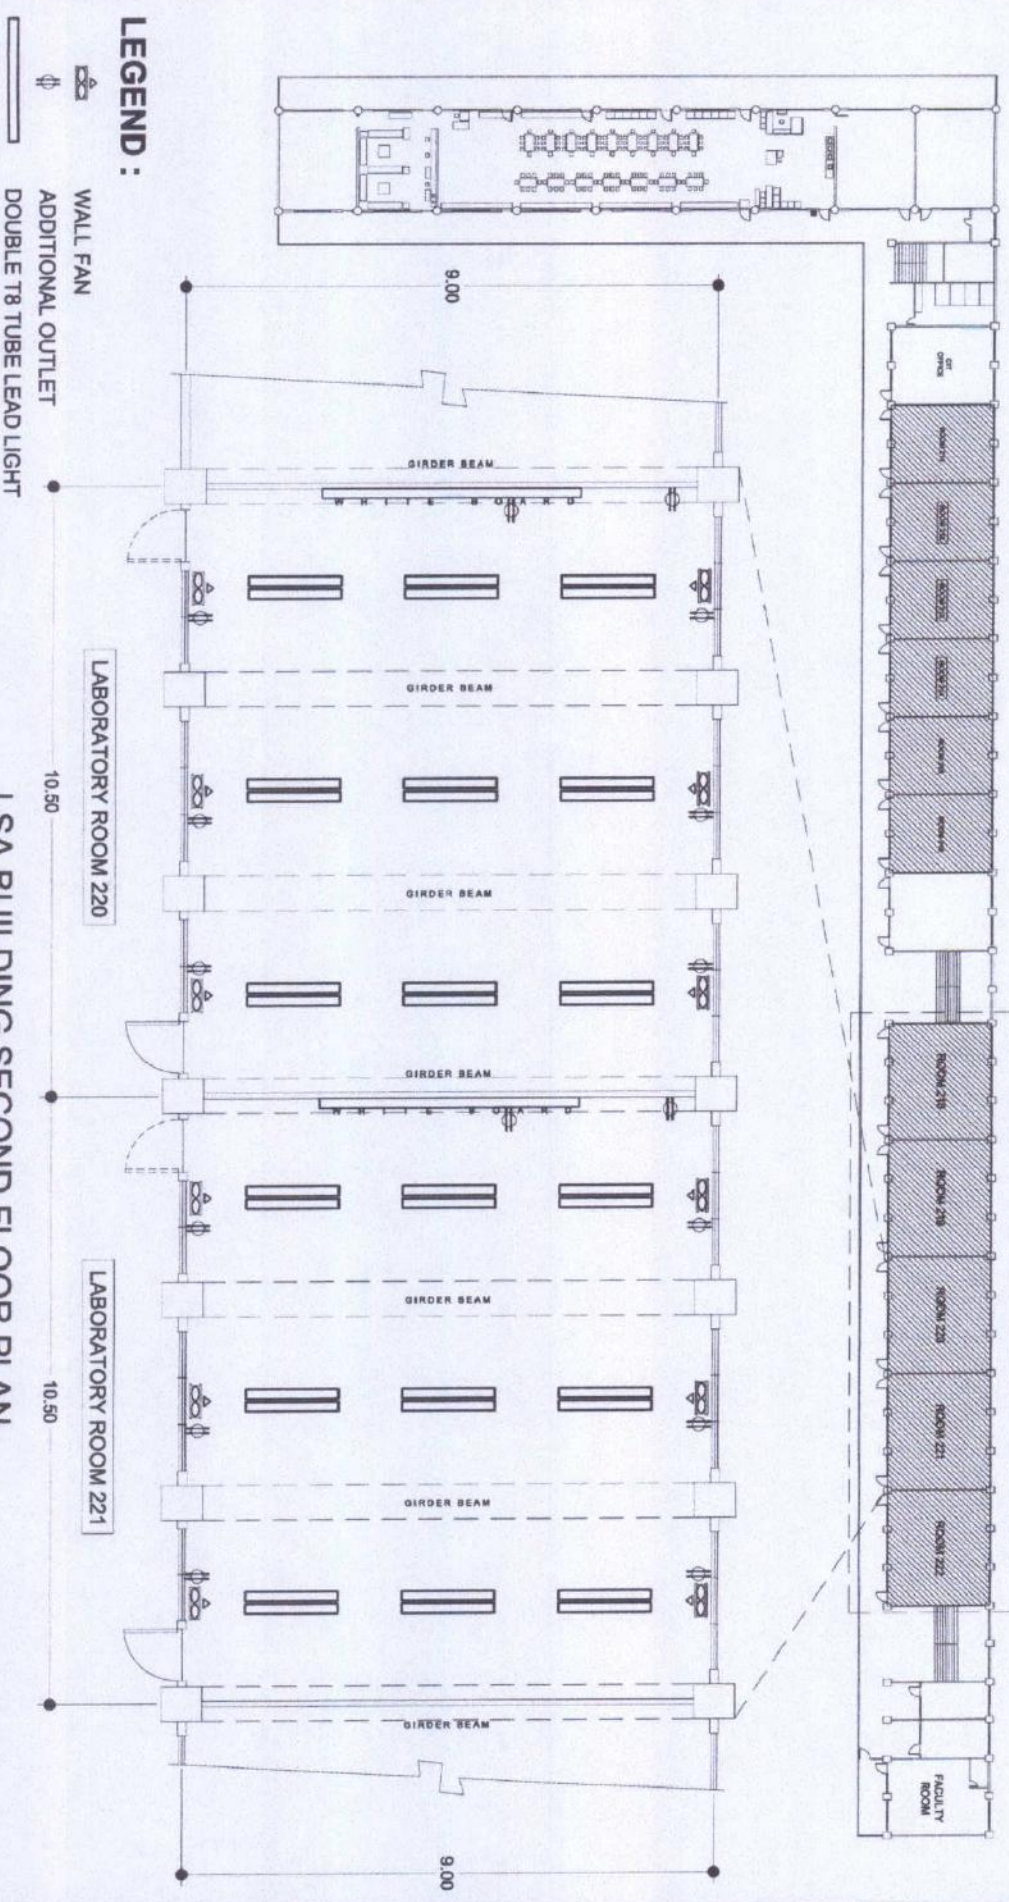
LOCATION OF LEAD LIGHT INSTALLATION




LEGEND :

-  WALL FAN
-  ADDITIONAL OUTLET
-  DOUBLE T8 TUBE LEAD LIGHT



USA BUILDING SECOND FLOOR PLAN
SCALE 1:100M

 <p>Republic of the Philippines CALIPO HILIGANONATIONAL STATE COLLEGE HIGAYON COLEGIO</p>		<p>PROJECT TITLE: PROPOSED CONVERSION OF LECTURE ROOMS TO NEW CLASSROOM SETTING - ELECTRICAL WORKS (PHASE 2)</p>		<p>PREPARED BY: ARNEL E. LATUBNAS COLLEGE ENGINEER</p>		<p>CHECKED BY: AS ENGR. JUAN J. MARQUEZ DIRECTOR</p>		<p>APPROVED BY: ROSAKRIDA S. TIVILLA, LIT VICE PRESIDENT FOR ADMINISTRATION</p>		<p>SHIRT NO.: A</p>	
<p>OFFICE OF THE ARCHITECTURAL AND ELECTRICAL ENGINEER</p>		<p>PROJECT LOCATION: TALAYAY CAMPUS</p>		<p>ENGR. JUAN J. MARQUEZ DIRECTOR</p>		<p>VICE PRESIDENT FOR ADMINISTRATION</p>		<p>NONRESIDENT SIC RESIDENT</p>		<p>PAGE NO.: 5</p>	


LOCATION OF LEAD LIGHT INSTALLATION

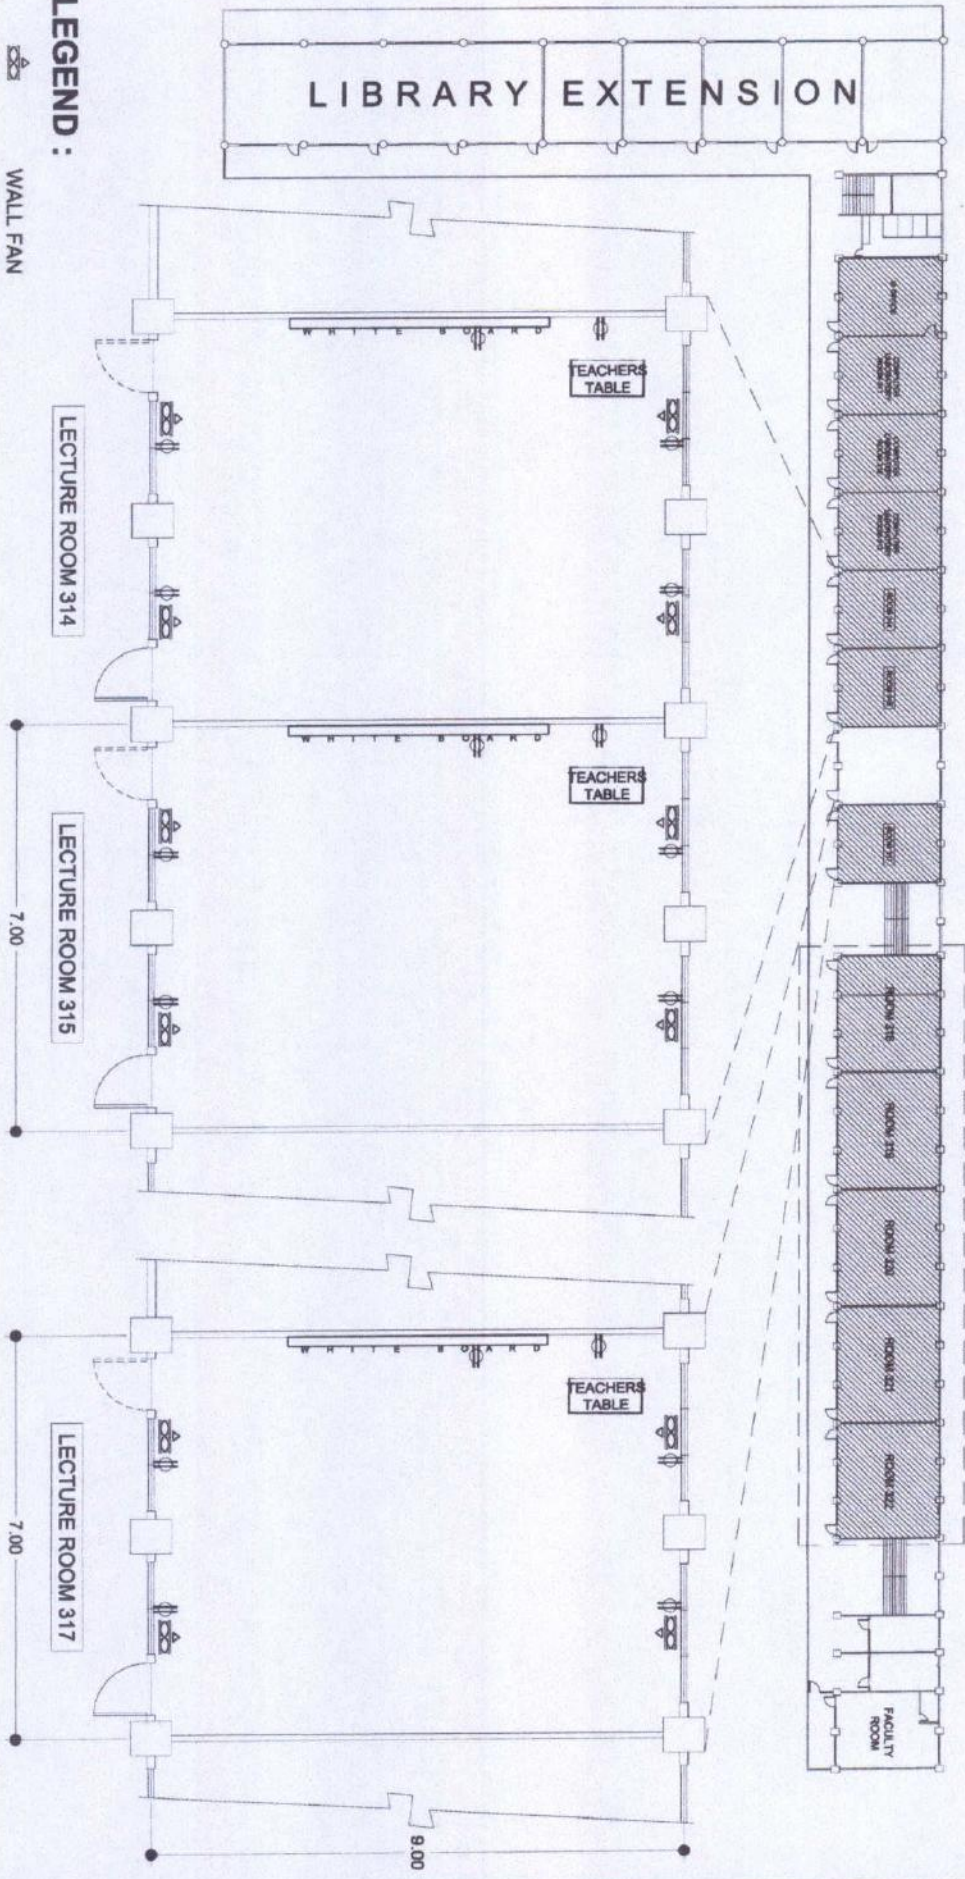

LEGEND :

 

-  WALL FAN
-  ADDITIONAL OUTLET


LSA BUILDING THIRD FLOOR PLAN
SCALE 1:100M

 Republic of the Philippines CALABON REGIONAL STATE COLLEGE NEGROS OCCIDENTAL OFFICE OF THE PHYSICAL PLANNING AND MANAGEMENT		PROJECT TITLE: PROPOSED CONVERSION OF LECTURE ROOMS TO NEW CLASSROOM SETTING - ELECTRICAL WORKS (PHASE 2) PROJECT LOCATION: TAYBAY CAMPUS		PREPARED BY: ABNEL E. LATUBERNAS COLLEGE PLANNING		CHECKED BY: ALBERTO S. SORIANO JR. COLLEGE PLANNING		DIRECTOR PWA: ENGR. JIMENEZ J. MARQUEZ		VICE PRESIDENT FOR ADMINISTRATION: ROSALINDA S. VENTURA, LIA		APPROVED BY: NORBERTO J. MINGULABANAN, Ph.D. DCC PRESIDENT		SHEET NO.: A		PAGE NO.: 6	
--------------------------------------------------------------------------------------------------------------------------------------------------------------------------------------------------------------------------------	--	--------------------------------------------------------------------------------------------------------------------------------------------------------------	--	----------------------------------------------------------------	--	------------------------------------------------------------------	--	--------------------------------------------------	--	------------------------------------------------------------------------	--	-------------------------------------------------------------------------	--	-------------------------------	--	------------------------------	--

LIBRARY EXTENSION

 
LEGEND :



-  WALL FAN
-  ADDITIONAL OUTLET

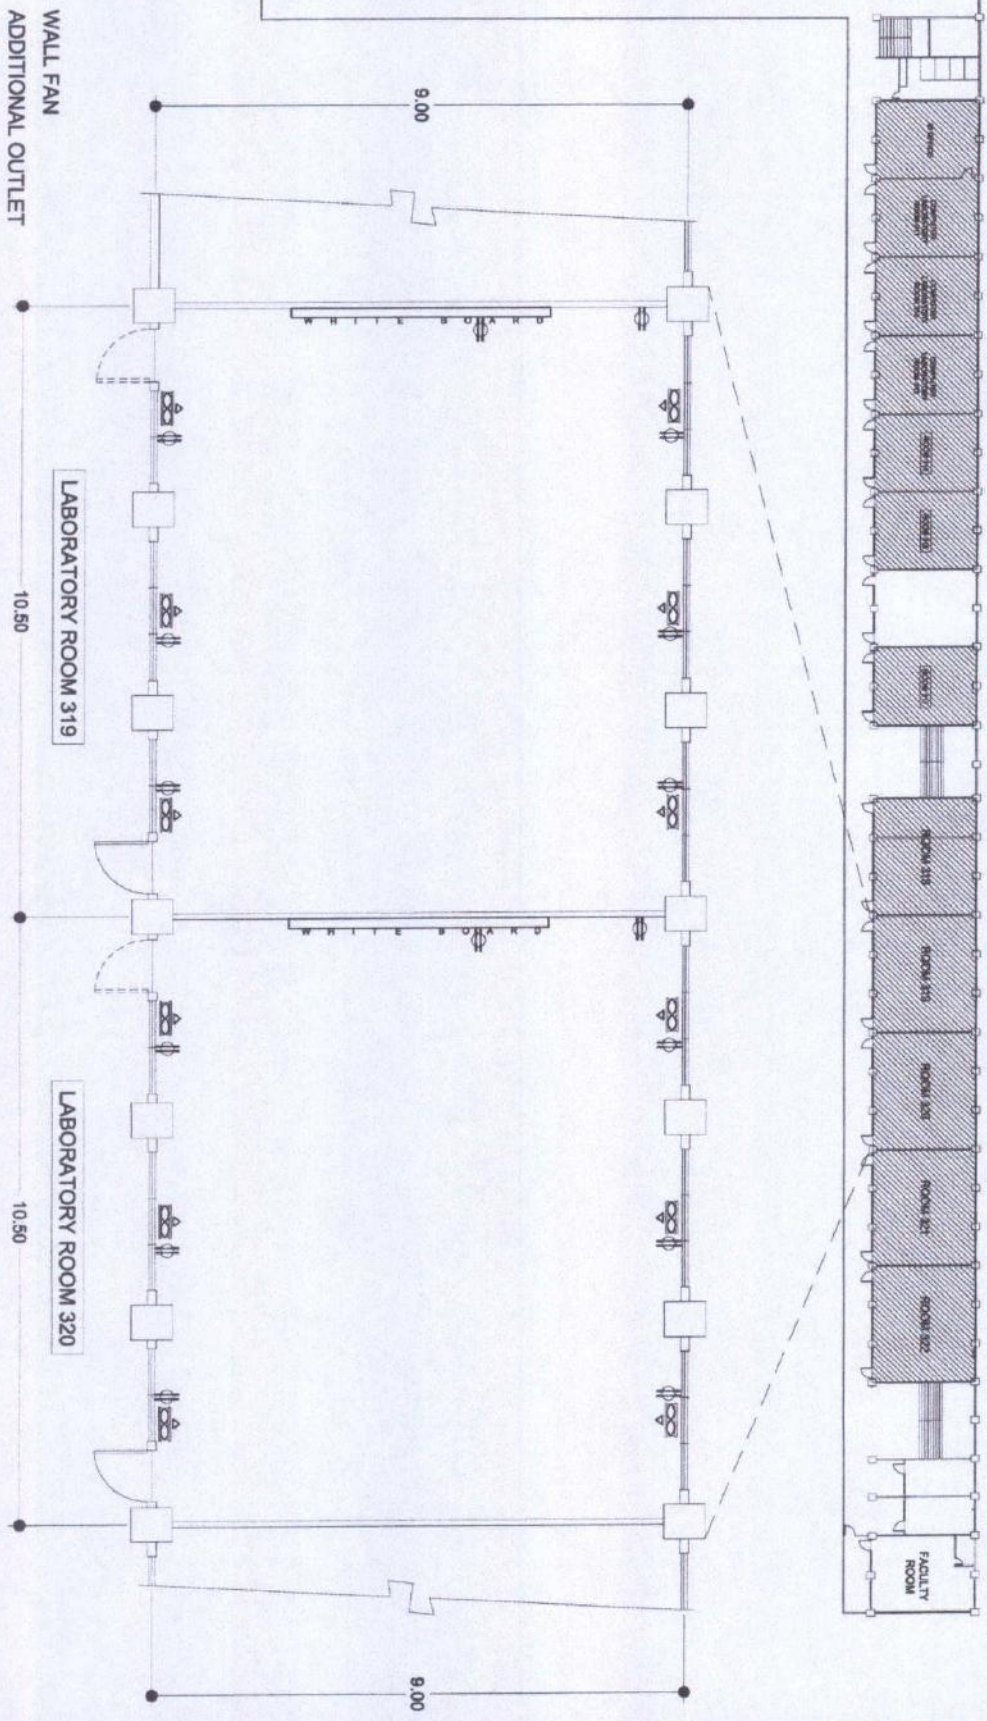

LSA BUILDING THIRD FLOOR PLAN



SCALE 1:100M


 Republic of the Philippines CALOOCAN HIGHER NATIONAL STATE COLLEGE Negros Occidental OFFICE OF THE ARCHITECT, PLANNING AND MAINTENANCE	PROJECT TITLE: PROPOSED CONVERSION OF LECTURE ROOMS TO NEW CLASSROOM SETTING - ELECTRICAL WORKS (PHASE 2) PROJECT LOCATION: TALIAY CAMPUS	PREPARED BY: ANNE L. LATURNA COLLEGE DEPUTYMAN	CHECKED BY: MR. ARNOLD COLLEGE DEPUTYMAN	ENGR. JESSE J. MARQUEZ DIRECTOR OF THE COLLEGE OF ENGINEERING	ROSALINDA T. REVILLA, LIS VICE PRESIDENT FOR ADMINISTRATION	APPROVED BY: NORBERTO M. GUILARMAN, PH.D. VICE PRESIDENT III	SHEET NO.: A	PAGE NO.: 7
----------------------------------------------------------------------------------------------------------------------------------------------------------------------------------------------------------------------------------------	-------------------------------------------------------------------------------------------------------------------------------------------------	------------------------------------------------------	------------------------------------------------	---------------------------------------------------------------------	----------------------------------------------------------------	--------------------------------------------------------------------	------------------------	-----------------------

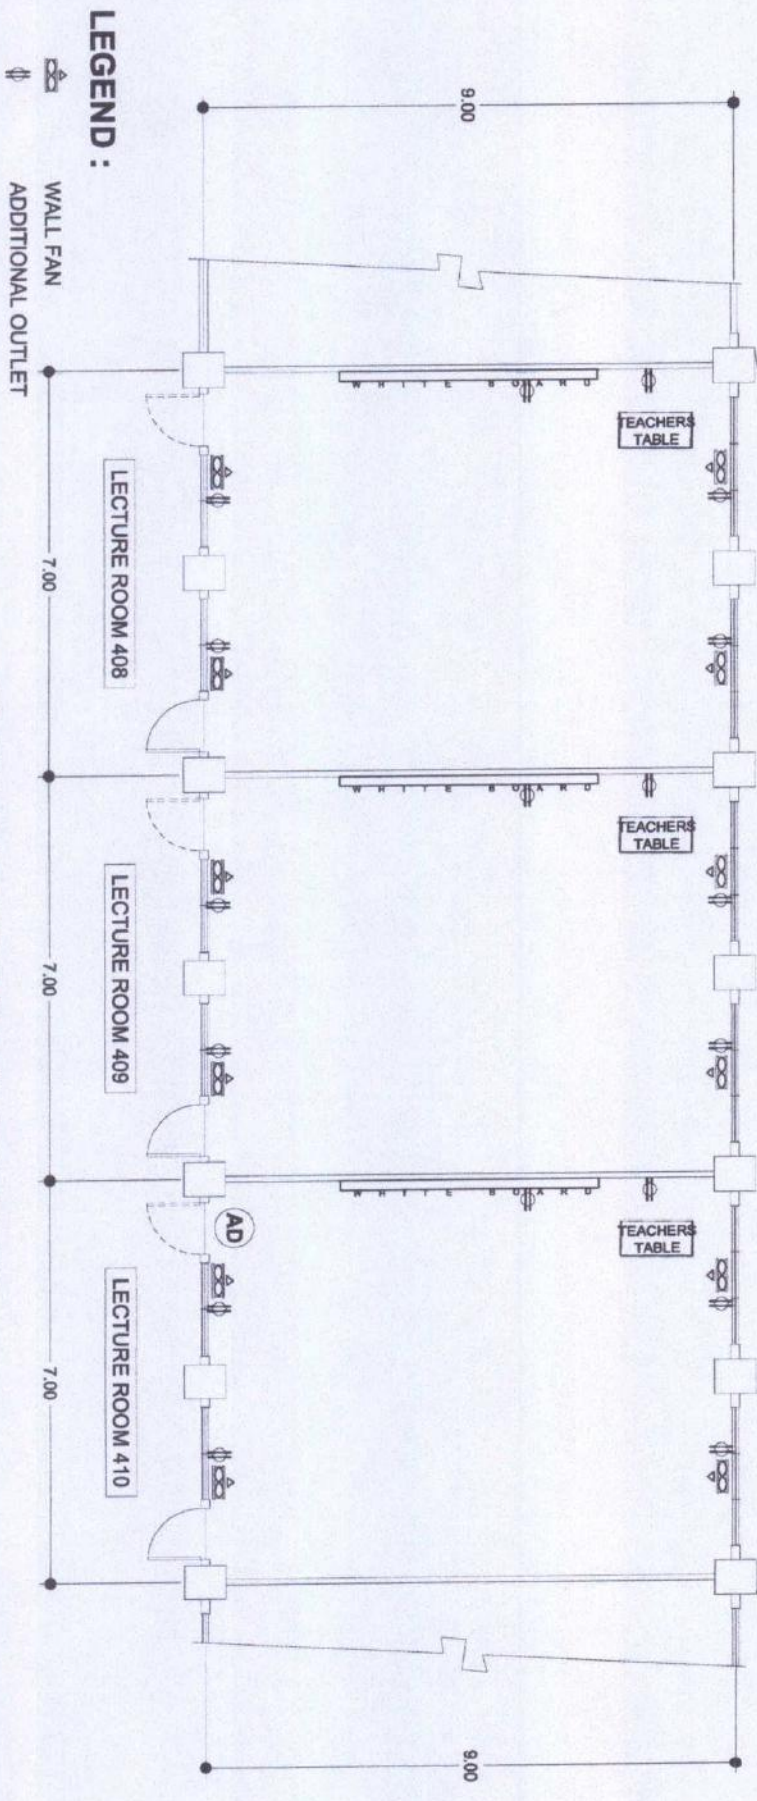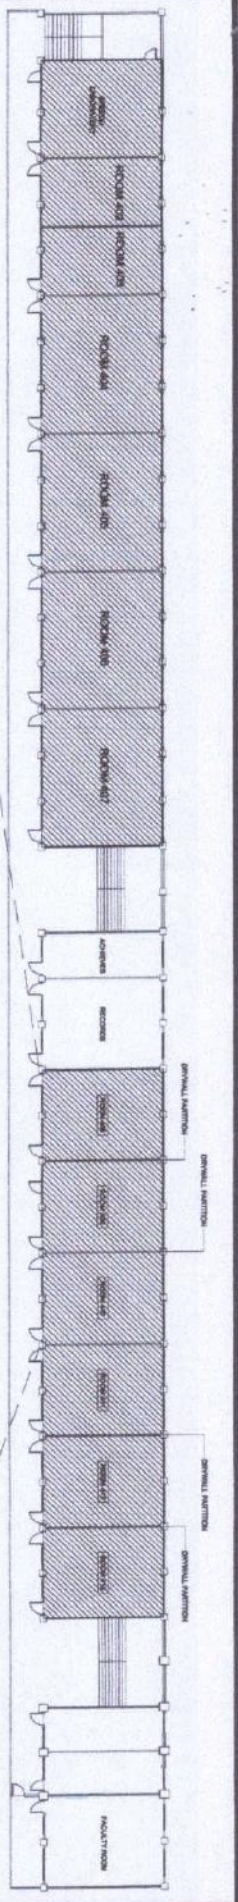


LSA BUILDING FOURTH FLOOR PLAN
SCALE 1:100M

  LEGEND :


-  WALL FAN
-  ADDITIONAL OUTLET

 Republic of the Philippines DEPARTMENT OF EDUCATION OFFICE OF THE NATIONAL DIRECTOR Higher Education AND MANAGEMENT		PROJECT TITLE: PROPOSED CONVERSION OF LECTURE ROOMS TO NEW CLASSROOM SETTING - ELECTRICAL WORKS (PHASE 2)		PROJECT LOCATION: TALSAY CAMPUS	
PREPARED BY: ANNEE R. LATUBINAS COURSE: ELECTRICAL ENGINEERING		CHECKED BY: [Signature] ENGR. JUAN J. MARGOTE DIRECTOR		APPROVED BY: [Signature] NOBBERTO P. MANCUALANAN, Ph.D. SBC MEMBER	
SHEET NO.: A		PAGE NO.: 8			

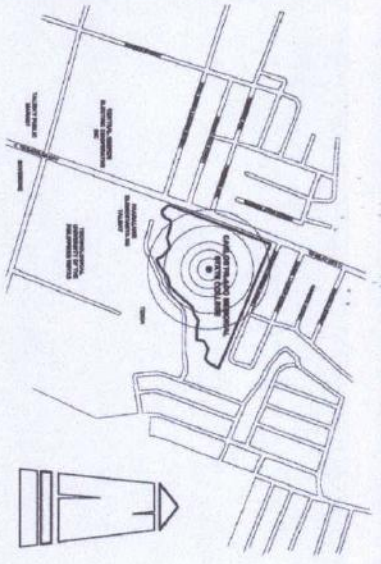


VICINITY MAP
SCALE NDTs

THE SITE

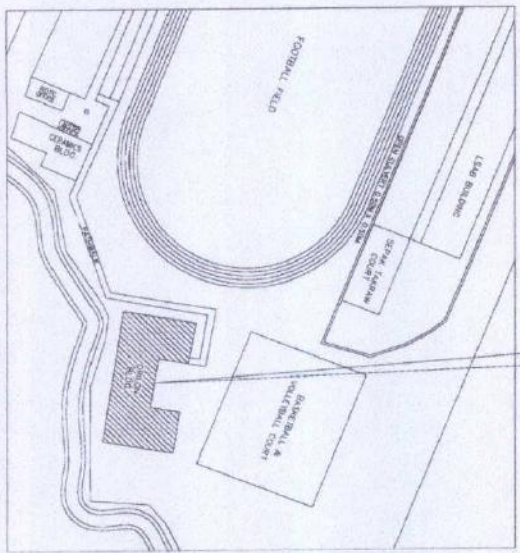

SITE DEVELOPMENT MAP
SCALE NDTs

- LIST OF ROOMS :**
- | | |
|--------------------------|--------------------------|
| GROUND FLOOR PLAN | SECOND FLOOR PLAN |
| ROOM 101 | ROOM 201 |
| ROOM 102 | ROOM 202 |
| ROOM 103 | ROOM 203 |
| ROOM 104 | ROOM 204 |
| ROOM 105 | ROOM 205 |
| ROOM 106 | ROOM 206 |

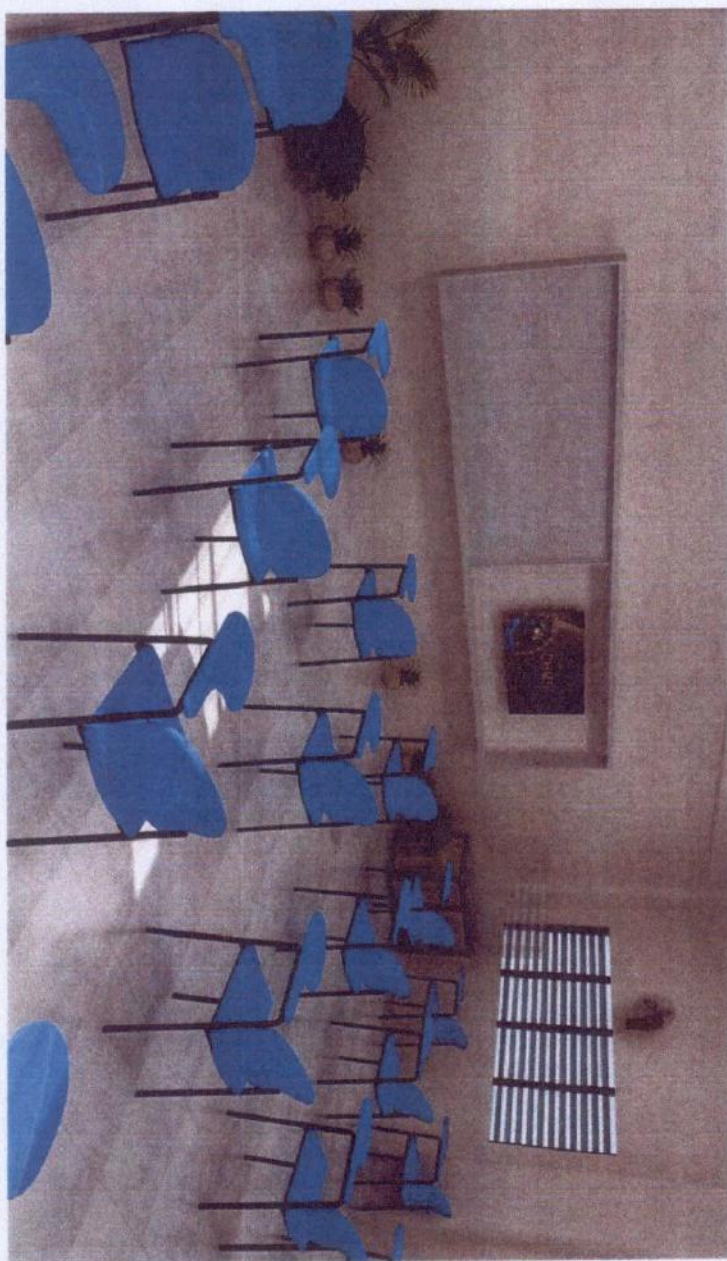


PERSPECTIVE DRAWING
SCALE NDTs

 <p>Republic of the Philippines COUNCIL ON HIGHER EDUCATION Negros Occidental</p>		<p>PROJECT TITLE: PROPOSED CONVERSION OF LECTURE ROOMS TO NEW CLASSROOM SETTING - ELECTRICAL WORKS (PHASE 2)</p>		<p>PREPARED BY: ANIEL R. LANTUANAS COLLECTOR BAHAYAN</p>		<p>CHECKED BY: AS. ANIEL R. LANTUANAS ENGR. GABRIEL S. DELA CRUZ JR. ENGR. GABRIEL S. DELA CRUZ JR.</p>		<p>ENGR. YUKI JUN T. MANGUERA DIRECTOR PFOA</p>		<p>ROSARINA S. TUVILLA, LIS VICE PRESIDENT FOR ADMINISTRATION</p>		<p>APPROVED BY: NORBERTO MANGILABANAN, Ph.D. DEC. PRESIDENT</p>		<p>SHEET NO.: A</p>		<p>PAGE NO.: 1</p>	
<p><small>OFFICE OF THE NATIONAL QUALITY ASSURANCE</small></p>		<p><small>PROJECT LOCATION: TALAY CAMPUS</small></p>		<p><small>COLLECTOR BAHAYAN</small></p>		<p><small>ENGR. YUKI JUN T. MANGUERA</small></p>		<p><small>ENGR. GABRIEL S. DELA CRUZ JR.</small></p>		<p><small>ENGR. GABRIEL S. DELA CRUZ JR.</small></p>		<p><small>AS. ANIEL R. LANTUANAS</small></p>		<p><small>AS. ANIEL R. LANTUANAS</small></p>		<p><small>AS. ANIEL R. LANTUANAS</small></p>	

LEGEND :


- > ROOM 101
10m x 10m 100 sqm.
- > ROOM 102
10m x 9m 90 sqm.
- > ROOM 103
10m x 9m 90 sqm.
- > ROOM 104
10m x 9m 90 sqm.
- > ROOM 105
10m x 9m 90 sqm.
- > ROOM 106
10m x 10m 100 sqm.

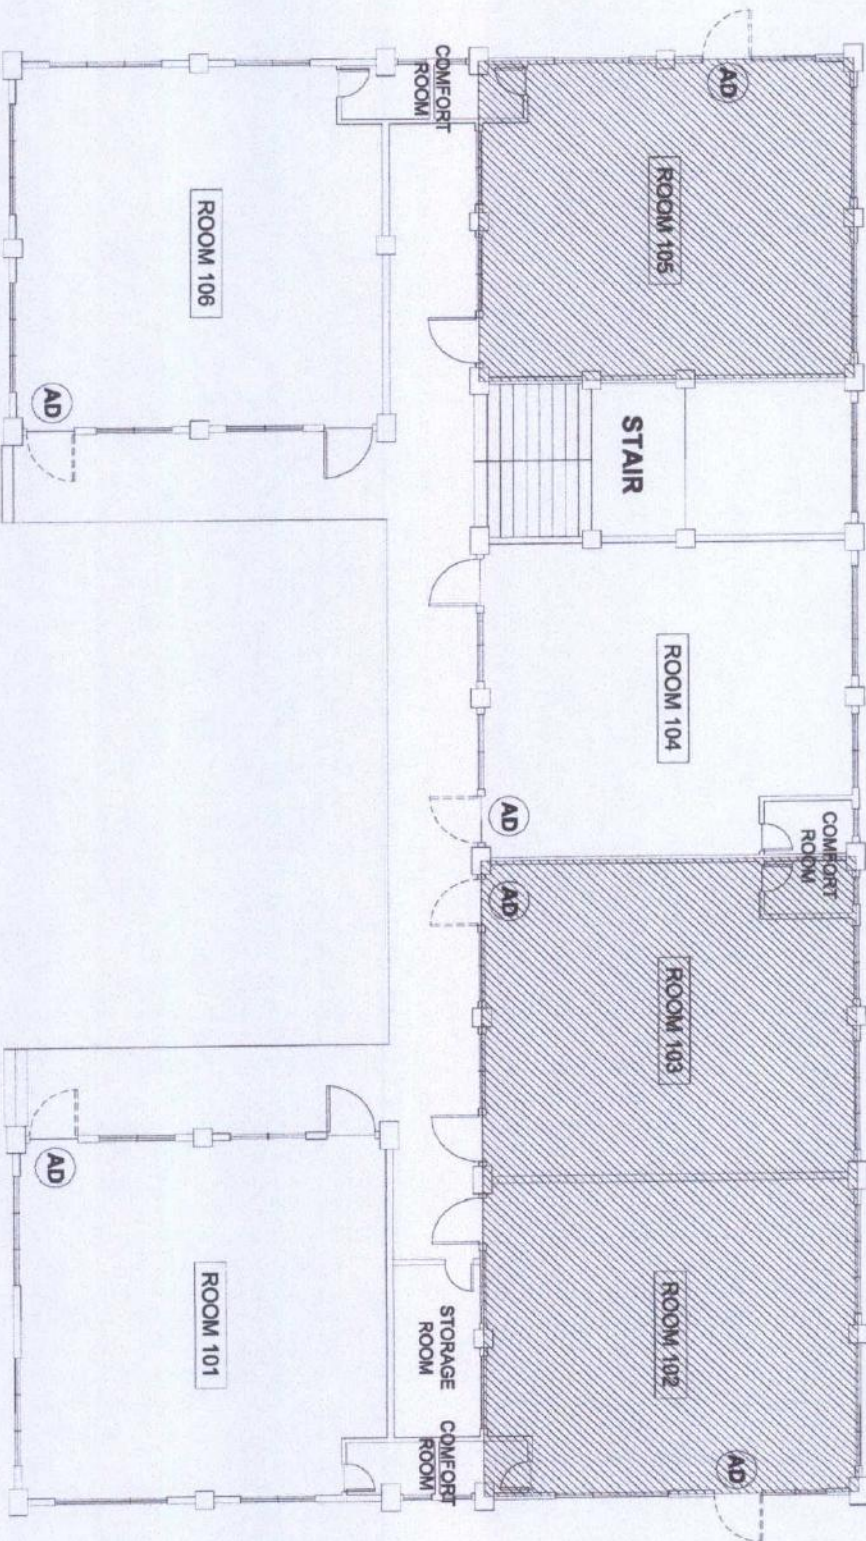

LEGEND :


- AD : ADDITIONAL DOOR
- 6 : NO OF WALL FAN/ROOM
- 25 : NO OF STUDENT CHAIR/ROOM
- 1 : NO OF TEACHERS TABLE/ROOM

TE BUILDING GROUND FLOOR PLAN
SCALE 1:100M

 <p>Republic of the Philippines DEPARTMENT OF EDUCATION OFFICE OF THE REGIONAL DIRECTOR CALABARZON REGION Bataan Campus Higher Education Center Bataan, Bataan</p>	<p>PROJECT TITLE: PROPOSED CONVERSION OF LECTURE ROOMS TO NEW CLASSROOM SETTING - ELECTRICAL WORKS (PHASE 2) PROJECT LOCATION: TALAYTAY CAMPUS</p>	<p>PREPARED BY: ANNEE E. LAYUNINAS COLLEGE DIAPYRNAN</p>	<p>CHECKED BY: AR. [Signature] BRIG. GENERAL [Signature]</p>	<p>ENGR. JUNIUN J. MANGUZO DIRECTOR PWD</p>	<p>ROSALYNDA S. TUPHILA, LHA VICE PRESIDENT FOR ADMINISTRATION</p>	<p>APPROVED BY: ROBERTO F. MANGULABANAN, Ph.D. RDC PRESIDENT</p>	<p>SHEET NO: A PAGE NO: 2</p>
----------------------------------------------------------------------------------------------------------------------------------------------------------------------------------------------------------------------------------------------------------------------------------------------------------------------------------	------------------------------------------------------------------------------------------------------------------------------------------------------------------------------	------------------------------------------------------------------------------------	----------------------------------------------------------------------------------------	----------------------------------------------------------	---------------------------------------------------------------------------------	--------------------------------------------------------------------------------------------	----------------------------------------------------------

LEGEND :


- > ROOM 201
10m x 10m 100 sqm.
- > ROOM 202
10m x 9m 90 sqm.
- > ROOM 203
10m x 9m 90 sqm.
- > ROOM 204
10m x 9m 90 sqm.
- > ROOM 205
10m x 9m 90 sqm.
- > ROOM 206
10m x 10m 100 sqm.

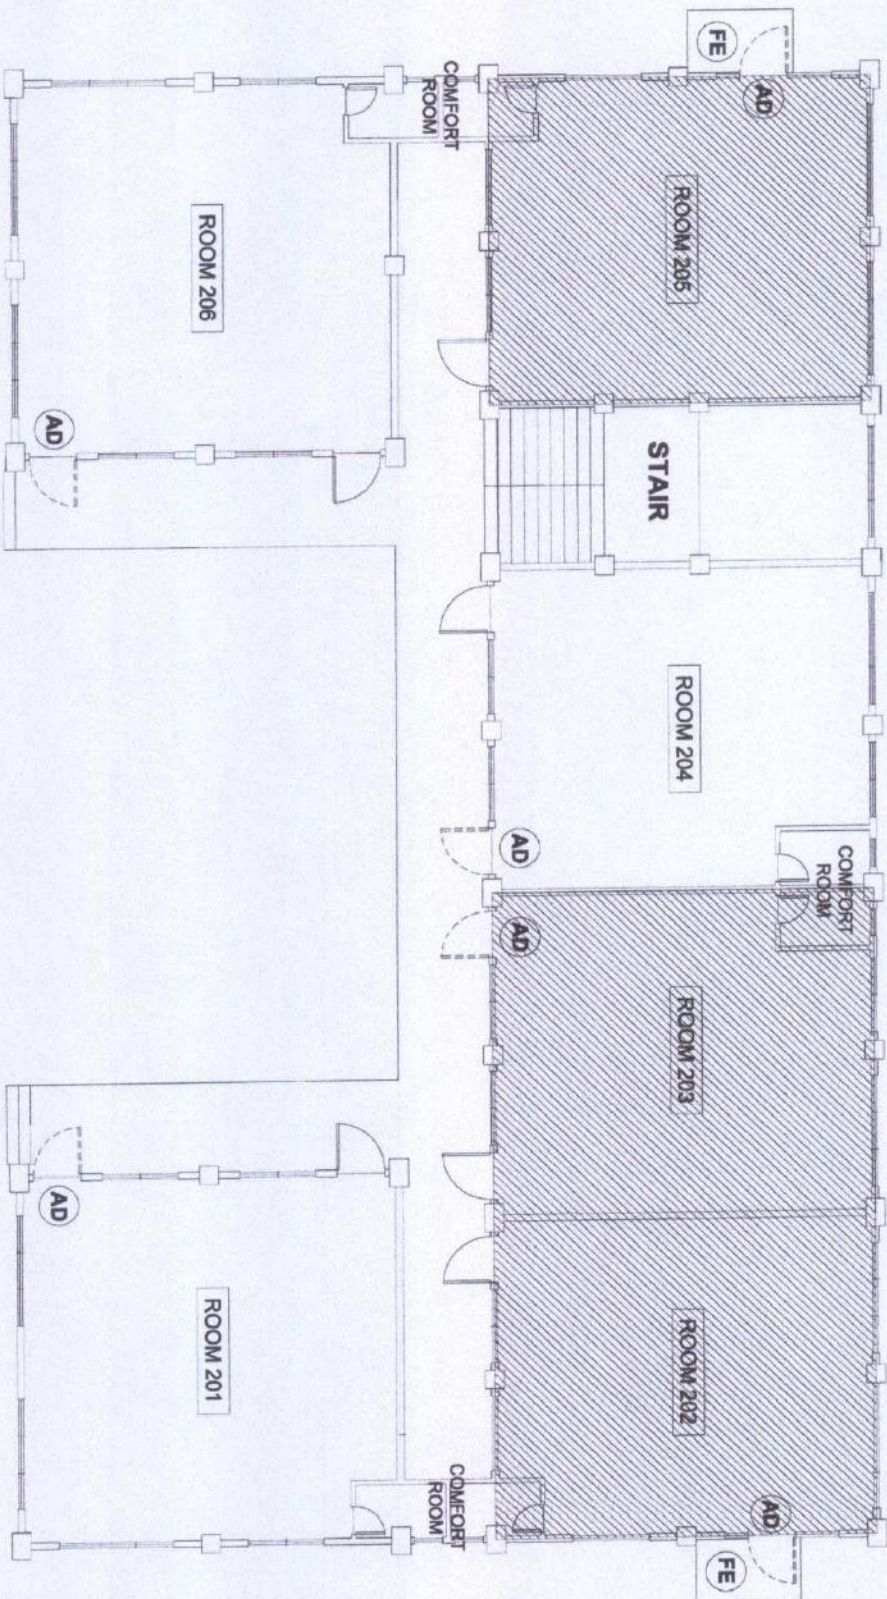


LEGEND :


- AD : ADDITIONAL DOOR
- 6 : NO OF WALL FAN/ROOM
- 25 : NO OF STUDENT CHAIR/ROOM
- 1 : NO OF TEACHERS TABLE/ROOM

TE BUILDING SECOND FLOOR PLAN
SCALE 1:100M


 <p>Republic of the Philippines CARLOS M. DELA ROSA BAYAN COLEGIO High School</p>		<p>PROJECT TITLE: PROPOSED CONVERSION OF LECTURE ROOMS TO NEW CLASSROOM SETTING - ELECTRICAL WORKS (PHASE 2)</p>		<p>PREPARED BY: ANNIE E. LATURNAS COLLECT DRAWING</p>		<p>CHECKED BY: AL ABRE ENGR. JOSE J. MANGUIRE DIRECTOR FROM</p>		<p>APPROVED BY: ROSA LINDA S. VILLALBA, ILE VICE PRESIDENT FOR ADMINISTRATION</p>		<p>SHEET NO. A</p>	
<p>OFFICE OF THE NATIONAL BOARD OF ARCHITECTS AND REGISTERED ARCHITECTS</p>		<p>PROJECT LOCATION: MALAYAL CAMPUS</p>		<p>COLLECT DRAWING</p>		<p>ENGR. JOSE J. MANGUIRE DIRECTOR FROM</p>		<p>VICE PRESIDENT FOR ADMINISTRATION</p>		<p>PAGE NO. 3</p>	

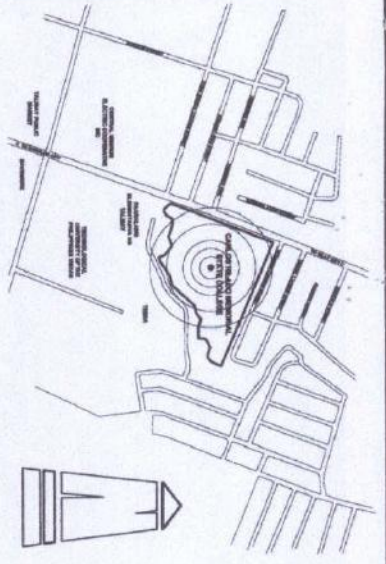


VICINITY MAP
SCALE NDTs

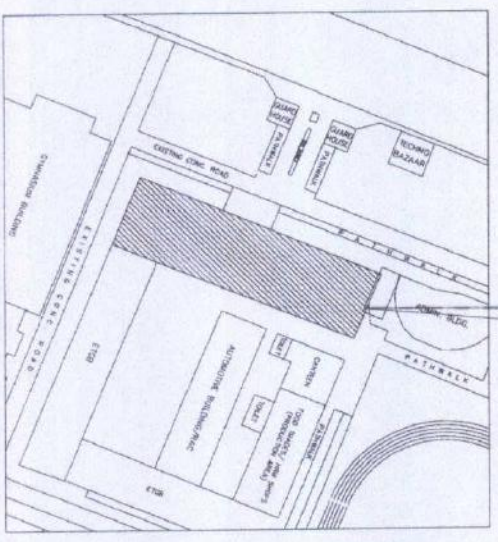

SITE DEVELOPMENT MAP
SCALE NDTs

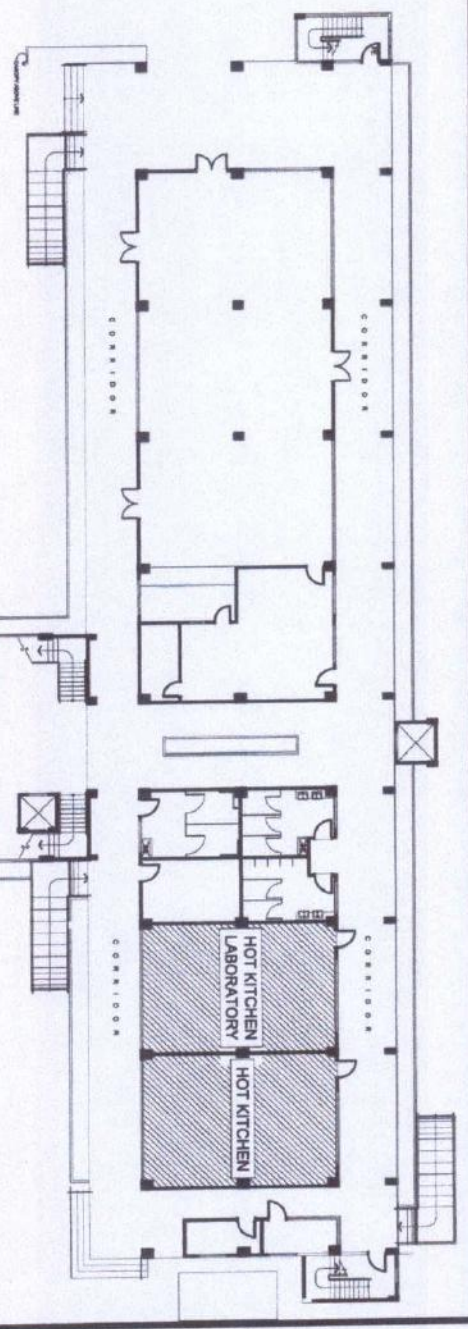

GREEN BUILDING GROUND FLOOR PLAN
SCALE 1/200'

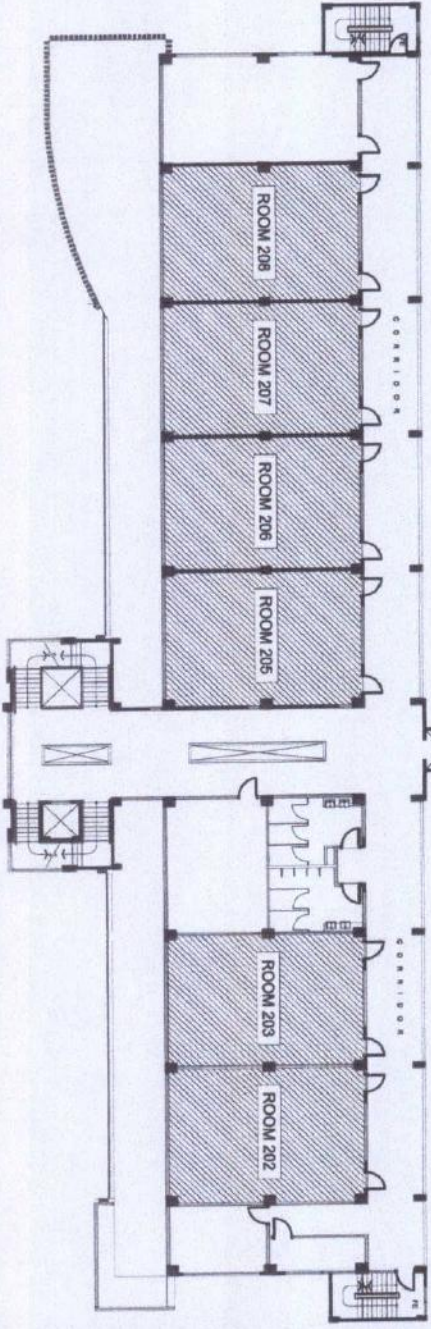

GREEN BUILDING SECOND FLOOR PLAN
SCALE 1/200'

 Republic of the Philippines CARLOS WILADO MORALES BANGGON NEGROS OCCIDENTAL OFFICE OF THE REGIONAL EDUCATION SUPERVISOR AND ADMINISTRATOR		PROJECT TITLE: PROPOSED CONVERSION OF LECTURE ROOMS TO NEW CLASSROOM SETTINGS - ELECTRICAL WORKS (PHASE 2)		PREPARED BY: ANNEE, E. LATURNAS COLLEGE DEPARTMENT		CHECKED BY: M. A. ANGELO COLLEGE DEPARTMENT		APPROVED BY: ROSAURINA S. TUWILA, LBS VICE PRESIDENT FOR ADMINISTRATION		SHEET NO. A	
PROJECT LOCATION: TALAY CAMPUS		PROJECT LOCATION: TALAY CAMPUS		CHECKED BY: ERIC SANTIAGO COLLEGE DEPARTMENT		APPROVED BY: NOBERTO P. MANGULABANAN, Ph.D. SUC PRESIDENT III		SHEET NO. A		PAGE NO. 4	



PROJECT REFERENCE No.: CHMSC 22-028-0623-I

I. PROJECT TITLE: **INSTALLATION OF CONVENIENCE OUTLETS AND CONVERSION OF CEILING LIGHT TO LED LIGHT
 IN THE LECTURE ROOMS AND LABORATORY ROOMS**

II. LOCATION: **TEB, ETGB and LSA BUILDING, CHMSC TALISAY CAMPUS**

III. SUBJECT: **PROGRAM OF WORKS**

IV. SCOPE OF WORKS

1.0 GENERAL REQUIREMENTS

- 1.1 Mobilization and Demobilization
- 1.2 Safety Occupational Hazards
- 1.3 Site Clearing, Cleaning and Hauling
- 1.4 Pull - Out of Existing Wall Fan and Ceiling Fan
- 1.5 Installation of New Wall Fan
- 1.6 Pull - Out of Existing Ceiling Light (Selected Rooms)

2.0 ELECTRICAL WORKS

- 2.1
- 2.1.1 Installation of 37 Sets 20m HDMI Cable and Smart TV Wiring (See Location Plan)
- 2.1.2 Installation Re-Wiring for Additional 355 Convenience Outlet for Smart TV, Teachers Table and Wall Fan (See Location Plan)
- 2.1.3 Installation of 260 Sets Wall Fan (See Location Plan)
- 2.1.4 Installation of 87 Ceiling Led Light 18 Watts T8 Double Tube x 1200mm (Selected Rooms)
- 2.1.4 Commissioning and Testing

PROJECT DURATION : 60 CALENDAR DAYS

BILL OF QUANTITIES

Item no.	Description of Works	Qty	Unit	Material Cost		Labor Cost		Total Amount	
				Unit Cost	Material Sub-total Cost	Unit Cost	Labor Sub-Total Cost	Contract	
1.0	GENERAL REQUIREMENTS								
1.1	Mobilization and Demobilization	1	lot						
1.2	Safety Occupational Hazards	1	lot						
1.3	Site Clearing, Cleaning and Hauling	1	lot						
1.4	Pull - Out of Existing Wall Fan and Ceiling Fan	260	lot						
1.5	Installation of New Wall Fan	260	Set						
1.6	Pull - Out of Existing Ceiling Light	87	Set						
	Sub-total, 1.0 (GENERAL REQUIREMENTS)			Sub-total ₱	-	Sub-total ₱	-	₱ -	
2.0	ELECTRICAL WORKS								
2.1	LSA BUILDING								
2.1.1	20m HDMI Cable and Smart TV Wiring at LSA Building (See Location Plan)	31	set						
2.1.2	Re-Wiring for Additional 2 Gang Universal Convenience Outlet for Smart TV, Teachers Table and Wall Fan at LSA Building (See Location Plan)	252	set						
2.1.3	Ceiling Led Light 18 Watts T8 Double Tube x 1200mm with Installation (Selected Rooms)	87	Set						
	Sub-total, 2.1 (ELECTRICAL WORKS)			Sub-total ₱	-	Sub-total ₱	-	₱ -	
2.1.4	TE BUILDING								
2.1.4	20m HDMI Cable and Smart TV Wiring at TE Building (See Location Plan)	6	set						
2.1.5	Re-Wiring for Additional 2 Gang Universal Convenience Outlet for Smart TV, Teachers Table and Wall Fan at TE Building (See Location Plan)	54	set						
2.1.6									
	Sub-total, 2.1 (ELECTRICAL WORKS)			Sub-total ₱	-	Sub-total ₱	-	₱ -	
2.1.7	ETG BUILDING								
2.1.7	Re-Wiring for Additional 2 Gang Universal Convenience Outlet for Smart TV, Teachers Table and Wall Fan at ETG Building (See Location Plan)	49	set						
	Sub-total, 2.1 (ELECTRICAL WORKS)			Sub-total ₱	-	Sub-total ₱	-	₱ -	
3.0	MISCELLANEOUS WORKS								
	FOR ALL OTHER ITEMS that are not included on listed Bill of Quantities in your Bid but are deemed necessary for the completion of the works and the delivery of the project and in full compliance with all the requirements of the occupancy permit.	1	lot						
	Sub-total, 3.0 (MISCELLANEOUS WORKS)							₱ -	
								A. TOTAL DIRECT COST	₱ -
								B. CONSUMABLES	₱ -
								C. SUPERVISION AND ADMINISTRATION	₱ -
								D. TOTAL INDIRECT COST (B + C)	₱ -
								E. TOTAL COST (A + D)	₱ -
								F. VAT (12% of Item E)	₱ -
								GRAND TOTAL PROJECT COST	₱ -