



Bid Notice Abstract

Request for Quotation (RFQ)

Reference Number 13234082
Procuring Entity CARLOS HILADO MEMORIAL STATE UNIVERSITY
Title Procurement of Labor and Materials for the Repair and Enhancement of tyhe Computer Laboratories at STGB- Alijis Campus
Area of Delivery Negros Occidental

Solicitation Number:	RFQ 26-443	Status	Pending
Trade Agreement:	Implementing Rules and Regulations		
Procurement Mode:	Negotiated Procurement - Small Value Procurement (Sec. 34)	Associated Components	5
Classification:	Civil Works	Bid Supplements	0
Category:	Construction Projects		
Approved Budget for the Contract:	PHP 185,000.00	Document Request List	0
Delivery Period:	45 Day/s		
Client Agency:		Date Published	10/09/2026
Contact Person:	Rowena De la Vida Prado Administrative Assistant II Mabini Street Talisay City Negros Occidental Philippines 6115 63-34-7120005 Ext.142 63-939-9296624 bac.sec@chmsu.edu.ph	Last Updated / Time	09/09/2026 09:57 AM
		Closing Date / Time	14/09/2026 17:00 PM

Description

Republic of the Philippines
CARLOS HILADO MEMORIAL STATE UNIVERSITY
Talisay City, Negros Occidental
Mobile Phone Number: (0920) 583 3046
bac.sec@chmsu.edu.ph
REQUEST FOR QUOTATION
Page 1 of 5
Date: SEPTEMBER 4, 2026
Quotation No. 26-443

Please quote your lowest price on the item/s listed below, stating the shortest time of delivery and submit your quotation duly signed by your representative not later than _____ in the return envelope attached herewith.

DR. MA. RIZA T. MANALO
BAC Chairperson
NOTE:

1. ALL ENTRIES MAY BE TYPEWRITTEN OR LEGIBLY HANDWRITTEN
2. DELIVERY PERIOD WITHIN 45 CALENDAR DAYS
3. WARRANTY SHALL BE FOR A PERIOD OF SIX (6) MONTHS FOR SUPPLIES & MATERIALS, ONE (1) YEAR FOR EQUIPMENT, FROM DATE OF ACCEPTANCE BY THE PROCURING ENTITY
4. PRICE VALIDITY SHALL BE FOR A PERIOD OF _____ CALENDAR DAYS
5. G-EPS REGISTRATION CERTIFICATE SHALL BE ATTACHED UPON SUBMISSION OF THE QUOTATION
6. BIDDERS SHALL SUBMIT ORIGINAL BROCHURES SHOWING CERTIFICATIONS OF THE PRODUCT BEING OFFERED

ITEM DESCRIPTION OF WORKS QTY. UNIT MATERIAL COST LABOR COST TOTAL COST

NO. Unit Cost Material Sub-Total Cost Unit Cost Labor Sub-Total Cost

ONE (1) LOT

LABOR AND MATERIALS FOR THE REPAIR AND ENHANCEMENT OF THE COMPUTER LABORATORIES AT STGB - ALIJIS CAMPUS

SCOPE OF WORKS

1.0 GENERAL WORKS

1.1 Mobilization and Demobilization

1.2 Clearing and Cleaning of Site

1.3 Safety Occupational Hazards

2.0 ELECTRICAL WORKS

2.1 Rehabilitation and Installation Works of Electrical System (Comlab 1)

2.2 Rehabilitation and Installation Works of Electrical System (Comlab 2)

2.3 Rehabilitation and Installation Works of Electrical System (Comlab 3)

3.0 PAINTING WORKS

3.1 Re-Painting of Walls, Ceiling, Columns, Baseboard and Computer Tables (Comlab 1)

3.2 Re-Painting of Walls, Ceiling, Columns, Baseboard and Computer Tables (Comlab 2)

3.3 Re-Painting of Walls, Ceiling, Columns, Baseboard and Computer Tables (Comlab 3)

4.0 SUPPLY AND INSTALLATION

4.1 Doorknob

5.0 MISCELLANEOUS WORKS

5.1 FOR ALL OTHER ITEMS that are not Included on listed Bill of Quantities in your Bid but are deemed necessary, incidental, or indispensable for the completion of the works and the delivery of the project, and in full compliance with all applicable laws, rules, regulations, codes, and requirements of the concerned government authorities.

BILL OF QUANTITIES

1.0 GENERAL WORKS

1.1 Mobilization and Demobilization 1.00 lot

1.2 Clearing and Cleaning of Site 1.00 lot

1.3 Safety Occupational Hazards 1.00 lot

Sub-total, 1.0 (GENERAL WORKS)

2.0 ELECTRICAL WORKS

2.1 Rehabilitation and Installation Works of Electrical System (Comlab 1)

2.1.1 Supply and Installation Works of the Electrical System, Including Rewiring with Mouldings and Junction Boxes, Installation of Floor Cord Covers, Repair of Existing Electrical Outlets, and Installation of Wiring from Tables to Junction Boxes and the Existing Panel Board 1.00 lot

2.2 Rehabilitation and Installation Works of Electrical System (Comlab 2)

2.2.1 Supply and Installation Works of the Electrical System, Including Rewiring with Mouldings and Junction Boxes, Installation of Floor Cord Covers, Repair of Existing Electrical Outlets, and Installation of Wiring from Tables to Junction Boxes and the Existing Panel Board 1.00 lot

2.3 Rehabilitation and Installation Works of Electrical System (Comlab 3)

2.3.1 Supply and Installation Works of the Electrical System, Including Rewiring with Mouldings and Junction Boxes, Installation of Floor Cord Covers, Repair of Existing Electrical Outlets, and Installation of Wiring from Tables to Junction Boxes and the Existing Panel Board 1.00 lot

Sub-total, 2.0 (ELECTRICAL WORKS)

3.0 PAINTING WORKS

3.1 Re-Painting of Walls, Ceiling, Columns, Baseboard and Computer Tables (Comlab 1)

3.1.1 Supply of paint materials and painting accessories, and the repainting of the Computer Laboratory, including the ceiling, walls, baseboards, and columns, Works include surface preparation, minor patching, priming where necessary, and application of the required finish coat (1 coat) 1.00 lot

3.2 Re-Painting of Walls, Ceiling, Columns, Baseboard and Computer Tables (Comlab 2)

3.2.1 Supply of paint materials and painting accessories, and the repainting of the Computer Laboratory, including the ceiling, walls, baseboards, and columns, Works include surface preparation, minor patching, priming where necessary, and application of the required finish coat (1 coat) 1.00 lot

3.3 Re-Painting of Walls, Ceiling, Columns, Baseboard and Computer Tables (Comlab 3)

3.3.1 Supply of paint materials and painting accessories, and the repainting of the Computer Laboratory, including the ceiling, walls, baseboards, and columns, Works include surface preparation, minor patching, priming where necessary, and application of the required finish coat (1 coat) 1.00 lot

Sub-total, 3.0(PAINTING WORKS)

4.0 SUPPLY AND INSTALLATION

4.1 Lever Type Doorknob (Heavy Duty) 6.00 set

Sub-total, 3.0(PAINTING WORKS)

5.0 MISCELLANEOUS

5.1 FOR ALL OTHER ITEMS that are not included on listed Bill of Quantities in your Bid but are deemed necessary, incidental, or indispensable for the completion of the works and the delivery of the project, and in full compliance with all applicable laws, rules, regulations, codes, and requirements of the concerned government authorities. 1.00 lot

Sub-total, 5.0 (Miscellaneous)

PROJECT DURATION: 45 CALENDAR DAYS

Note: Attach Certificate of Site Inspection

A. TOTAL DIRECT COST

B. CONSUMABLES:

C. SUPERVISION AND ADMINISTRATION:

D. TOTAL INDIRECT COST (B+C):

E. TOTAL COST (A+D)

F. VAT (12% OF ITEM E):
 GRAND TOTAL OF PROJECT COST:
 *****NOTHING FOLLOWS*****
 TOTAL ABC = Php 185,000.00
 PROCUREMENT OF LABOR AND MATERIALS FOR THE REPAIR AND ENHANCEMENT OF THE COMPUTER LABORATORIES
 AT STGB - ALIJIS CAMPUS - J.M. DORMIDO (Dean, CCS)
 PR# 26-867-0824 08-24-26
 INCOME 498-164-26-08 08-26-26
Line Items

Item No.	Product/Service Name	Description	Quantity UOM		Budget (PHP)
1	ONE (1) LOT	Labor and Materials for the Repair and Enhancement of tyhe Computer Laboratories at STGB- Alijis Campus	1	Lot	185,000.00

Created by Rowena De la Vida Prado
Date Created 09/09/2026


The PhilGEPS team is not responsible for any typographical errors or misinformation presented in the system. PhilGEPS only displays information provided for by its clients, and any queries regarding the postings should be directed to the contact person/s of the concerned party.



Republic of the Philippines
CARLOS HILADO MEMORIAL STATE UNIVERSITY
Talisay City, Negros Occidental
Mobile Phone Number: (0920) 583 3046
bac.sec@chmsu.edu.ph
REQUEST FOR QUOTATION

Page 1 of 5
Date: SEPTEMBER 4, 2026
Quotation No. 26-443

Please quote your lowest price on the item/s listed below, stating the shortest time of delivery and submit your quotation duly signed by your representative not later than _____ in the return envelope attached herewith.

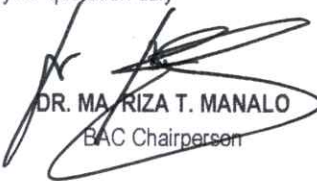
DR. MA. RIZA T. MANALO
BAC Chairperson

NOTE:

1. ALL ENTRIES MAY BE TYPEWRITTEN OR LEGIBLY HANDWRITTEN
2. DELIVERY PERIOD WITHIN 45 CALENDAR DAYS
3. WARRANTY SHALL BE FOR A PERIOD OF SIX (6) MONTHS FOR SUPPLIES & MATERIALS, ONE (1) YEAR FOR EQUIPMENT, FROM DATE OF ACCEPTANCE BY THE PROCURING ENTITY
4. PRICE VALIDITY SHALL BE FOR A PERIOD OF _____ CALENDAR DAYS
5. G-EPIS REGISTRATION CERTIFICATE SHALL BE ATTACHED UPON SUBMISSION OF THE QUOTATION
6. BIDDERS SHALL SUBMIT ORIGINAL BROCHURES SHOWING CERTIFICATIONS OF THE PRODUCT BEING OFFERED

ITEM NO.	DESCRIPTION OF WORKS	QTY.	UNIT	MATERIAL COST		LABOR COST		TOTAL COST
				Unit Cost	Material Sub-Total Cost	Unit Cost	Labor Sub-Total Cost	
	ONE (1) LOT							
	LABOR AND MATERIALS FOR THE REPAIR AND ENHANCEMENT OF THE COMPUTER LABORATORIES AT STGB - ALIJIS CAMPUS							
	SCOPE OF WORKS							
1.0	GENERAL WORKS							
1.1	Mobilization and Demobilization							
1.2	Clearing and Cleaning of Site							
1.3	Safety Occupational Hazards							
2.0	ELECTRICAL WORKS							
2.1	Rehabilitation and Installation Works of Electrical System (Comlab 1)							
2.2	Rehabilitation and Installation Works of Electrical System (Comlab 2)							
2.3	Rehabilitation and Installation Works of Electrical System (Comlab 3)							
3.0	PAINTING WORKS							
3.1	Re-Painting of Walls, Ceiling, Columns, Baseboard and Computer Tables(Comlab 1)							
3.2	Re-Painting of Walls, Ceiling, Columns, Baseboard and Computer Tables(Comlab 2)							
3.3	Re-Painting of Walls, Ceiling, Columns, Baseboard and Computer Tables (Comlab 3)							

Date _____ By _____

Released (BAC) _____
Returned (Supplier) _____

Printed Name/Signature _____

Tel. No./Cellphone No. _____

Date _____



Republic of the Philippines
CARLOS HILADO MEMORIAL STATE UNIVERSITY
Talisay City, Negros Occidental
Mobile Phone Number: (0920) 583 3046
bac.sec@chmsu.edu.ph
REQUEST FOR QUOTATION

Page 2 of 5
Date: SEPTEMBER 4, 2026
Quotation No. 26-443

Please quote your lowest price on the item/s listed below, stating the shortest time of delivery and submit your quotation duly signed by your representative not later than _____ in the return envelope attached herewith.


DR. MA. RIZA T. MANALO
BAC Chairperson

NOTE:

- 1. ALL ENTRIES MAY BE TYPEWRITTEN OR LEGIBLY HANDWRITTEN
- 2. DELIVERY PERIOD WITHIN 45 CALENDAR DAYS
- 3. WARRANTY SHALL BE FOR A PERIOD OF SIX (6) MONTHS FOR SUPPLIES & MATERIALS, ONE (1) YEAR FOR EQUIPMENT, FROM DATE OF ACCEPTANCE BY THE PROCURING ENTITY
- 4. PRICE VALIDITY SHALL BE FOR A PERIOD OF _____ CALENDAR DAYS
- 5. G-EPS REGISTRATION CERTIFICATE SHALL BE ATTACHED UPON SUBMISSION OF THE QUOTATION
- 6. BIDDERS SHALL SUBMIT ORIGINAL BROCHURES SHOWING CERTIFICATIONS OF THE PRODUCT BEING OFFERED

ITEM NO.	DESCRIPTION OF WORKS	QTY.	UNIT	MATERIAL COST		LABOR COST		TOTAL COST
				Unit Cost	Material Sub-Total Cost	Unit Cost	Labor Sub-Total Cost	
4.0	SUPPLY AND INSTALLATION							
4.1	Door Knob							
5.0	MISCELLANEOUS WORKS							
5.1	FOR ALL OTHER ITEMS that are not included on listed Bill of Quantities in your Bid but are deemed necessary, incidental, or indispensable for the completion of the works and the delivery of the project, and in full compliance with all applicable laws, rules, regulations, codes, and requirements of the concerned government authorities.							
	BILL OF QUANTITIES							
1.0	GENERAL WORKS							
1.1	Mobilization and Demobilization	1.00	lot					
1.2	Clearing and Cleaning of Site	1.00	lot					
1.3	Safety Occupational Hazards	1.00	lot					
	Sub-total, 1.0 (GENERAL WORKS)							
2.0	ELECTRICAL WORKS							
2.1	Rehabilitation and Installation Works of Electrical System (Comlab 1)							
2.1.1	Supply and Installation Works of the Electrical System, Including Rewiring with Mouldings and Junction Boxes, Installation of Floor Cord Covers, Repair of Existing Electrical Outlets, and Installation of Wiring from Tables to Junction Boxes and the Existing Panel Board	1.00	lot					

Released (BAC) _____
Returned (Supplier) _____

Printed Name/Signature

Tel. No./Cellphone No.

Date



Republic of the Philippines
CARLOS HILADO MEMORIAL STATE UNIVERSITY
Talisay City, Negros Occidental
Mobile Phone Number: (0920) 583 3046
bac.sec@chmsu.edu.ph
REQUEST FOR QUOTATION

Page 3 of 5
Date: SEPTEMBER 4, 2026
Quotation No. 26-443

Please quote your lowest price on the item/s listed below, stating the shortest time of delivery and submit your quotation duly signed by your representative not later than _____ in the return envelope attached herewith.


DR. MA. RIZA T. MANALO
BAC Chairperson

- NOTE:
- 1. ALL ENTRIES MAY BE TYPEWRITTEN OR LEGIBLY HANDWRITTEN
 - 2. DELIVERY PERIOD WITHIN 45 CALENDAR DAYS
 - 3. WARRANTY SHALL BE FOR A PERIOD OF SIX (6) MONTHS FOR SUPPLIES & MATERIALS, ONE (1) YEAR FOR EQUIPMENT, FROM DATE OF ACCEPTANCE BY THE PROCURING ENTITY
 - 4. PRICE VALIDITY SHALL BE FOR A PERIOD OF _____ CALENDAR DAYS
 - 5. G-EPS REGISTRATION CERTIFICATE SHALL BE ATTACHED UPON SUBMISSION OF THE QUOTATION
 - 6. BIDDERS SHALL SUBMIT ORIGINAL BROCHURES SHOWING CERTIFICATIONS OF THE PRODUCT BEING OFFERED

ITEM NO.	DESCRIPTION OF WORKS	QTY.	UNIT	MATERIAL COST		LABOR COST		TOTAL COST
				Unit Cost	Material Sub-Total Cost	Unit Cost	Labor Sub-Total Cost	
2.2	Rehabilitation and Installation Works of Electrical System (Comlab 2)							
2.2.1	Supply and Installation Works of the Electrical System, Including Rewiring with Mouldings and Junction Boxes, Installation of Floor Cord Covers, Repair of Existing Electrical Outlets, and Installation of Wiring from Tables to Junction Boxes and the Existing Panel Board	1.00	lot					
2.3	Rehabilitation and Installation Works of Electrical System (Comlab 3)							
2.3.1	Supply and Installation Works of the Electrical System, Including Rewiring with Mouldings and Junction Boxes, Installation of Floor Cord Covers, Repair of Existing Electrical Outlets, and Installation of Wiring from Tables to Junction Boxes and the Existing Panel Board	1.00	lot					
	Sub-total, 2.0 (ELECTRICAL WORKS)							
3.0	PAINTING WORKS							
3.1	Re-Painting of Walls, Ceiling, Columns, Baseboard and Computer Tables (Comlab 1)							
3.1.1	Supply of paint materials and painting accessories, and the repainting of the Computer Laboratory, including the ceiling, walls, baseboards, and columns, Works include surface preparation, minor patching, priming where necessary, and application of the required finish coat (1 coat)	1.00	lot					

Date _____ By _____
Released (BAC) _____
Returned (Supplier) _____

Printed Name/Signature

Tel. No./Cellphone No.


Date



Republic of the Philippines
CARLOS HILADO MEMORIAL STATE UNIVERSITY
Talisay City, Negros Occidental
Mobile Phone Number: (0920) 583 3046
bac.sec@chmsu.edu.ph
REQUEST FOR QUOTATION

Page 4 of 5
Date: SEPTEMBER 4, 2026
Quotation No. 26-443

Please quote your lowest price on the item/s listed below, stating the shortest time of delivery and submit your quotation duly signed by your representative not later than _____ in the return envelope attached herewith.

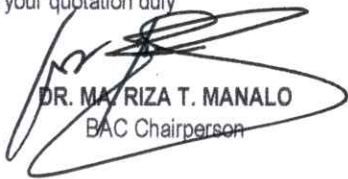
DR. MA RIZA T. MANALO
BAC Chairperson

- NOTE:**
- 1. ALL ENTRIES MAY BE TYPEWRITTEN OR LEGIBLY HANDWRITTEN
 - 2. DELIVERY PERIOD WITHIN 45 CALENDAR DAYS
 - 3. WARRANTY SHALL BE FOR A PERIOD OF SIX (6) MONTHS FOR SUPPLIES & MATERIALS, ONE (1) YEAR FOR EQUIPMENT, FROM DATE OF ACCEPTANCE BY THE PROCURING ENTITY
 - 4. PRICE VALIDITY SHALL BE FOR A PERIOD OF _____ CALENDAR DAYS
 - 5. G-EPIS REGISTRATION CERTIFICATE SHALL BE ATTACHED UPON SUBMISSION OF THE QUOTATION
 - 6. BIDDERS SHALL SUBMIT ORIGINAL BROCHURES SHOWING CERTIFICATIONS OF THE PRODUCT BEING OFFERED

ITEM NO.	DESCRIPTION OF WORKS	QTY.	UNIT	MATERIAL COST		LABOR COST		TOTAL COST
				Unit Cost	Material Sub-Total Cost	Unit Cost	Labor Sub-Total Cost	
3.2	Re-Painting of Walls, Ceiling, Columns, Baseboard and Computer Tables (Comlab 2)							
3.2.1	Supply of paint materials and painting accessories, and the repainting of the Computer Laboratory, including the ceiling, walls, baseboards, and columns, Works include surface preparation, minor patching, priming where necessary, and application of the required finish coat (1 coat)	1.00	lot					
3.3	Re-Painting of Walls, Ceiling, Columns, Baseboard and Computer Tables (Comlab 3)							
3.3.1	Supply of paint materials and painting accessories, and the repainting of the Computer Laboratory, including the ceiling, walls, baseboards, and columns, Works include surface preparation, minor patching, priming where necessary, and application of the required finish coat (1 coat)	1.00	lot					
	Sub-total, 3.0(PAINTING WORKS)							
4.0	SUPPLY AND INSTALLATION							
4.1	Lever Type Door Knob (Heavy Duty)	6.00	set					
	Sub-total, 3.0(PAINTING WORKS)							
5.0	MISCELLANEOUS							

Released (BAC) _____ Date _____ By _____
Returned (Supplier) _____

Printed Name/Signature

Tel. No./Cellphone No.

Date




Republic of the Philippines
CARLOS HILADO MEMORIAL STATE UNIVERSITY
Talisay City, Negros Occidental
Mobile Phone Number: (0920) 583 3046
bac.sec@chmsu.edu.ph
REQUEST FOR QUOTATION

Page 5 of 5

Date: SEPTEMBER 4, 2026

Quotation No. 26-443

Please quote your lowest price on the item/s listed below, stating the shortest time of delivery and submit your quotation duly signed by your representative not later than _____ in the return envelope attached herewith.

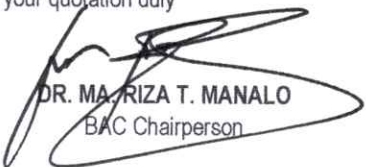
DR. MA. RIZA T. MANALO
BAC Chairperson

NOTE:

1. ALL ENTRIES MAY BE TYPEWRITTEN OR LEGIBLY HANDWRITTEN
2. DELIVERY PERIOD WITHIN 45 CALENDAR DAYS
3. WARRANTY SHALL BE FOR A PERIOD OF SIX (6) MONTHS FOR SUPPLIES & MATERIALS, ONE (1) YEAR FOR EQUIPMENT, FROM DATE OF ACCEPTANCE BY THE PROCURING ENTITY
4. PRICE VALIDITY SHALL BE FOR A PERIOD OF _____ CALENDAR DAYS
5. G-EPS REGISTRATION CERTIFICATE SHALL BE ATTACHED UPON SUBMISSION OF THE QUOTATION
6. BIDDERS SHALL SUBMIT ORIGINAL BROCHURES SHOWING CERTIFICATIONS OF THE PRODUCT BEING OFFERED

ITEM NO.	DESCRIPTION OF WORKS	QTY.	UNIT	MATERIAL COST		LABOR COST		TOTAL COST
				Unit Cost	Material Sub-Total Cost	Unit Cost	Labor Sub-Total Cost	
5.1	FOR ALL OTHER ITEMS that are not included on listed Bill of Quantities in your Bid but are deemed necessities, incidental, or indispensable for the completion of the works and the delivery of the project, and in full compliance with all applicable laws, rules, regulations, codes, and requirements of the concerned government authorities.	1.00	lot					
	Sub-total, 5.0 (Miscellaneous)							
	PROJECT DURATION: 45 CALENDAR DAYS							
	Note: Attach Certificate of Site Inspection							
	A. TOTAL DIRECT COST							
	B. CONSUMABLES:							
	C. SUPERVISION AND ADMINISTRATION:							
	D. TOTAL INDIRECT COST (B+C):							
	E. TOTAL COST (A+D)							
	F. VAT (12% OF ITEM E):							
	GRAND TOTAL OF PROJECT COST:							
	*****NOTHING FOLLOWS*****							
	TOTAL ABC = Php 185,000.00							
	PROCUREMENT OF LABOR AND MATERIALS FOR THE REPAIR AND ENHANCEMENT OF THE COMPUTER LABORATORIES AT STGB - ALIJIS CAMPUS - J.M. DORMIDO (Dean, CCS)							
	PR# 26-867-0824 08-24-26							
	INCOME 498-164-26-08 08-26-26							

Date _____ By _____


Released (BAC) _____
Returned (Supplier) _____

Printed Name/Signature _____


Tel. No./Cellphone No. _____

Date _____

26-443

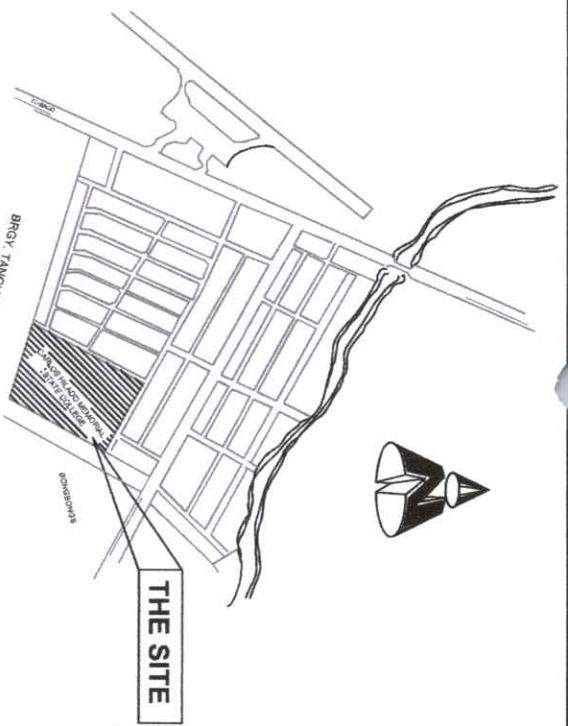

VICINITY MAP

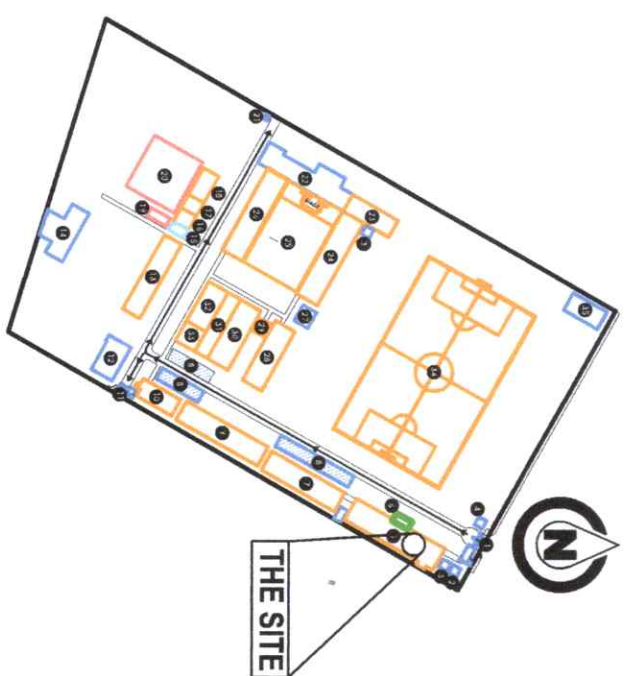


SITE DEVELOPMENT PLAN



PERSPECTIVE


 Republic of the Philippines CARLOS BLADO MEMORIAL STATE UNIVERSITY Negros Occidental		PROJECT TITLE:		ENDORSED BY:		PREPARED BY:		CHECKED BY:		RECOMMENDING APPROVAL:		APPROVED BY:		SHEET NO:		PAGE NO:			
REPAIR AND ENHANCEMENT OF THE COMPUTER LABORATORIES AT ALIIS CAMPUS				 ENGR. JOSE MARIA SUPV. OF CONSTRUCTION		 ENGR. J. C. GARCIA UNIVERSITY ENGINEER IN CHARGE - ALIIS CAMPUS		 ENGR. J. C. GARCIA SUPV. OF CONSTRUCTION		 ENGR. J. C. GARCIA UNIVERSITY ENGINEER IN CHARGE - ALIIS CAMPUS		 ENGR. J. C. GARCIA UNIVERSITY ENGINEER IN CHARGE - ALIIS CAMPUS		 ENGR. J. C. GARCIA UNIVERSITY ENGINEER IN CHARGE - ALIIS CAMPUS		CS 1		2	
OFFICE OF THE PROJECT MANAGEMENT UNIT		PROJECT LOCATION: ALIIS CAMPUS		EXECUTIVE DIRECTOR, ALIIS CAMPUS		ADMIN. OFFICER & PROJECT MANAGEMENT UNIT - ALIIS		PROJECT DEVELOPMENT OFFICER M. MAU		DIRECTOR, PROJECT MANAGEMENT UNIT		VICE PRESIDENT FOR ADMINISTRATION		SUC. PRESIDENT III					



EXISTING COMPUTER LABORATORIES
NOTE: Change Table Arrangement based on the proposed plan, Repainting the
Tables and Walls

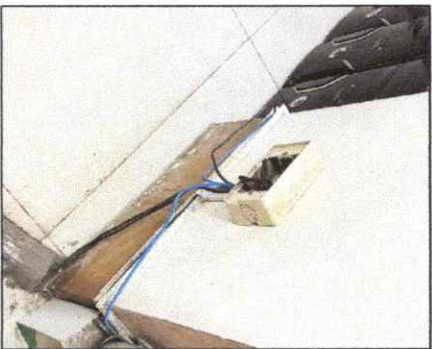


EXISTING ELECTRICAL LINES

 NOTE: Existing electrical lines shall be removed and replaced with new electrical wiring, install new raceways, junction boxes, and accessories as required.

 Republic of the Philippines CARLOS M. ROLLO MEMORIAL STATE UNIVERSITY Negros Occidental	PROJECT TITLE:		ENDORSED BY:		PREPARED BY:		CHECKED BY:		RECOMMENDING APPROVAL:		APPROVED BY:		SHEET NO:		PAGE NO:		
	REPAIR AND ENHANCEMENT OF THE COMPUTER LABORATORIES AT ALIUS CAMPUS		ENGR. JOE MARIE D. DOMINCO, DR. B.S. in Civil Engineering, M.S. in Civil Engineering UNIVERSITY OF THE PHILIPPINES - ALIUS CAMPUS		FRANCIS R. JAYEN UNIVERSITY OF THE PHILIPPINES - ALIUS CAMPUS		AR. JENNY M. LACALAN, UAP POLICE OFFICER (TRAINING OFFICER) UAP		ENGR. JUN-JUN J. MORALES VICE PRESIDENT FOR ADMINISTRATION		NORBERTO P. MANCUALABNAN, PH.D. SUC PRESIDENT III		CS 2 2		2		
OFFICE OF THE PROJECT MANAGEMENT UNIT		PROJECT LOCATION: ALIUS CAMPUS		GLEN FERRIN G. GARCIA, MS. EXECUTIVE DIRECTOR, ALIUS CAMPUS		ENGR. JOSEPH MARK E. BENAMIRA ASST. DIR. OF GEN. MGMT. MANAGEMENT UNIT - ALIUS		PROJECT INVESTMENT OFFICER, PMU		DIRECTOR OF PROJECT MANAGEMENT UNIT							

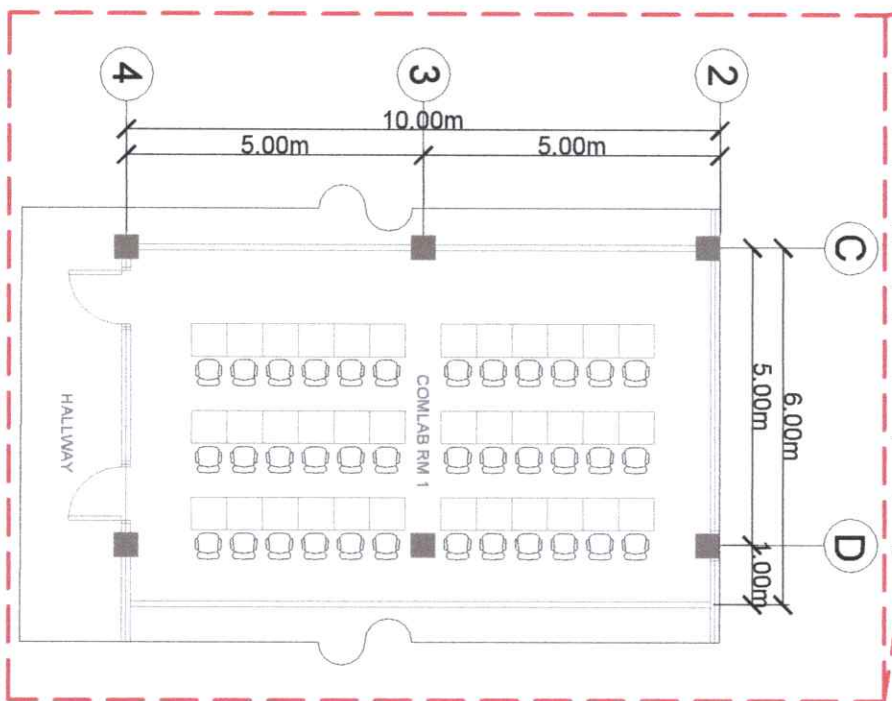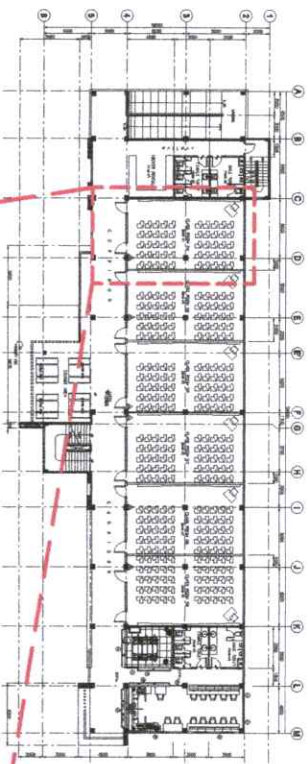



1 EXISTING FLOOR PLAN COM LAB 1, 2ND FLOOR STGB BUILDING
A/01 SCALE: 1:120MTS

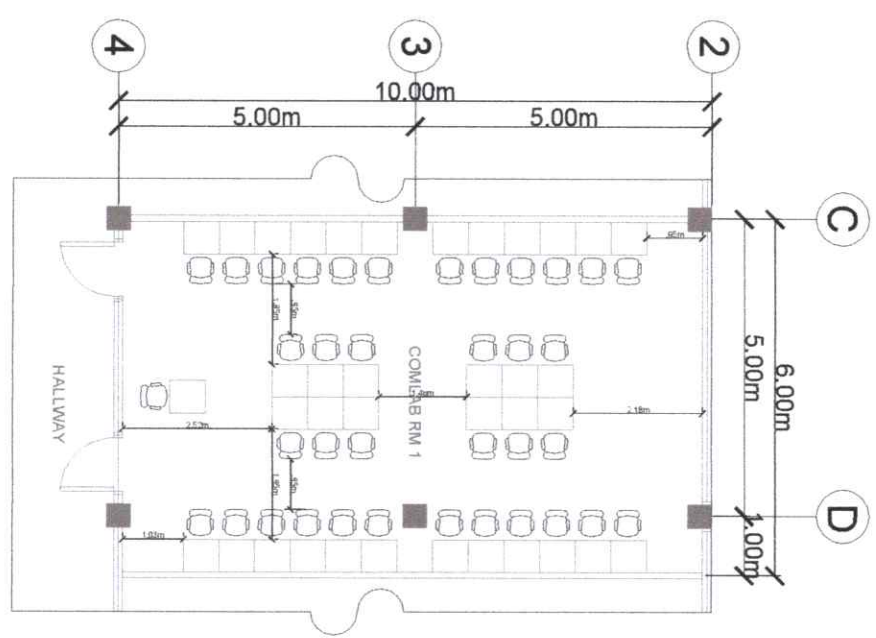


2 PROPOSED FLOOR PLAN COM LAB 1, 2ND FLOOR STGB BUILDING
A/01 SCALE: 1:120MTS

 Republic of the Philippines CATIGS MILADO MEMORIAL STATE UNIVERSITY Negros Occidental		PROJECT TITLE: REPAIR AND ENHANCEMENT OF THE COMPUTER LABORATORIES AT ALJIS CAMPUS		ENDORSED BY: ENGR. JOE MARIE S. SORIANO JR. CHIEF, OFFICE OF THE PROJECT MANAGEMENT UNIT - ALJIS CAMPUS		PREPARED BY: FRANZINE E. JACOB UNIVERSITY OF THE PHILIPPINES - ALJIS CAMPUS		CHECKED BY: ABENIG M. S. SORIANO JR. PROJECT MANAGER, OFFICE OF THE PROJECT MANAGEMENT UNIT - ALJIS CAMPUS		RECOMMENDING APPROVAL: ENGR. JUN-JUN J. MARQUEZ DIRECTOR, PROJECT MANAGEMENT UNIT		APPROVED BY: JAY B. ESTRELLAS, EDD. VICE PRESIDENT FOR ADMINISTRATION AND FINANCE		SHEET NO.: A		PAGE NO.: 16	
--	--	--	--	---	--	---	--	--	--	---	--	---	--	-----------------	--	-----------------	--


26-443

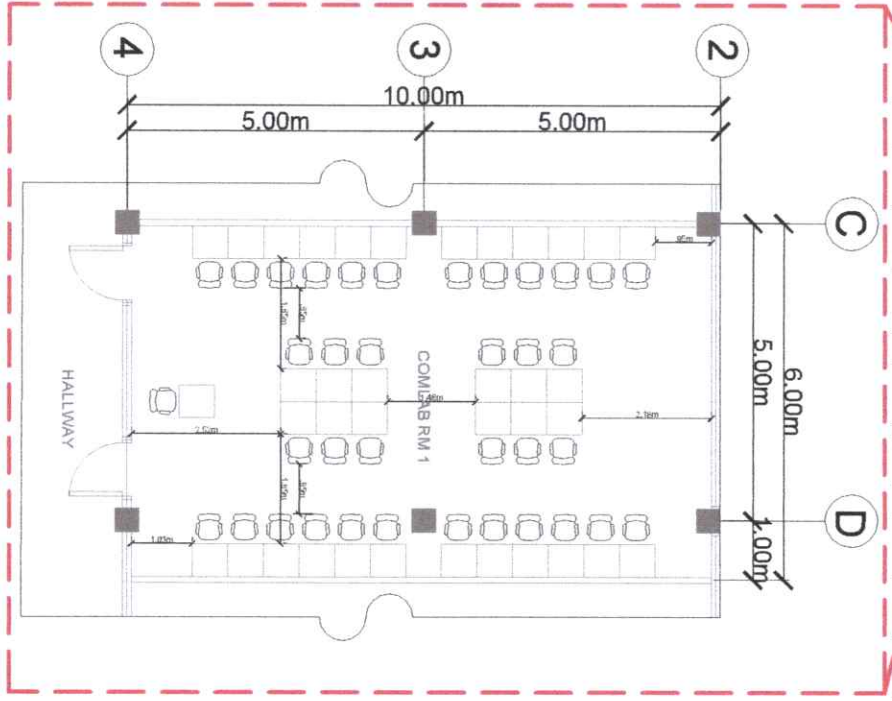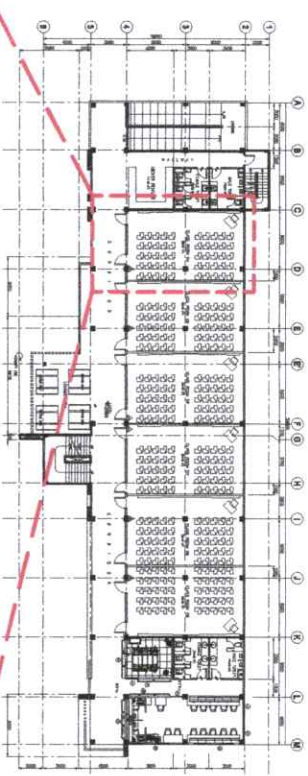

1 COMLAB 1 FLOOR PLAN 2ND FLOOR STGB BUILDING
A02 SCALE: 1:120MTS


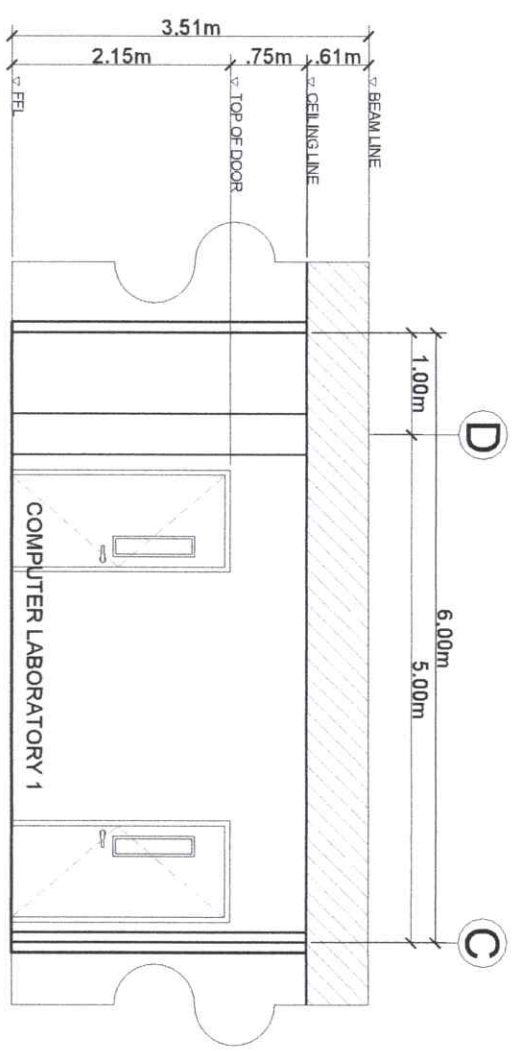


2 COMPUTER LABORATORY 1
SECTION THRU 'X-X'
A02 SCALE: 1:70MTS

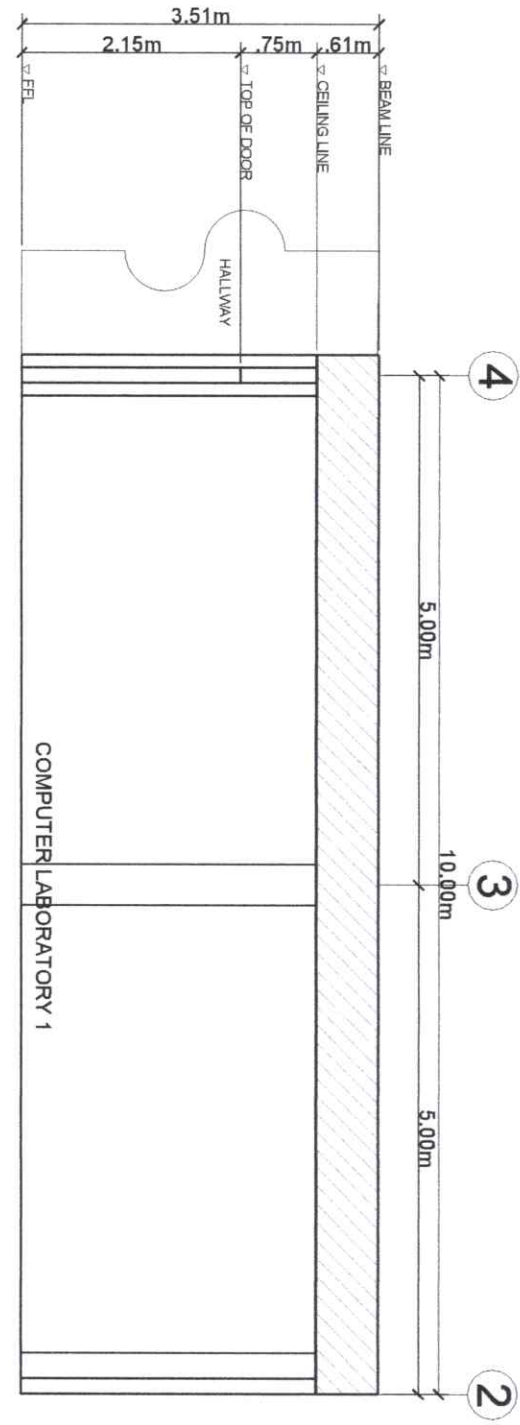


3 COMPUTER LABORATORY 1
SECTION THRU 'Y-Y'
A02 SCALE: 1:70MTS

 Republic of the Philippines CARLOS HILADO MEMORIAL STATE UNIVERSITY Negros Occidental	PROJECT TITLE: REPAIR AND ENHANCEMENT OF THE COMPUTER LABORATORIES AT ALJIS CAMPUS		ENDORSED BY:  ENGR. JOACK MACAR, JR. CHIEF OF DIVISION OFFICE UNIVERSITY OF THE PHILIPPINES - MARIKINA CITY		CHECKED BY:  ARIEL M. MORALES, UP PROJECT ENGINEER		RECOMMENDING APPROVAL:  ENGR. JUN-JUN J. MANQUEZ DIRECTOR, PROJECT MANAGEMENT UNIT		APPROVED BY:  NORBERTO P. MANGULABNAN, PH.D. SUC PRESIDENT III		SHEET NO.: A	PAGE NO.: 26
	PROJECT LOCATION: ALJIS CAMPUS		EXECUTIVE DIRECTOR: ALJIS CAMPUS ENGR. JOHN MARK B. BENAMIRA		ADMIN. OFFICER IN CHARGE: MANAGEMENT UNIT - ALJIS ENGR. JOCK MACAR, JR.		VICE PRESIDENT FOR ADMINISTRATION AND FINANCE					

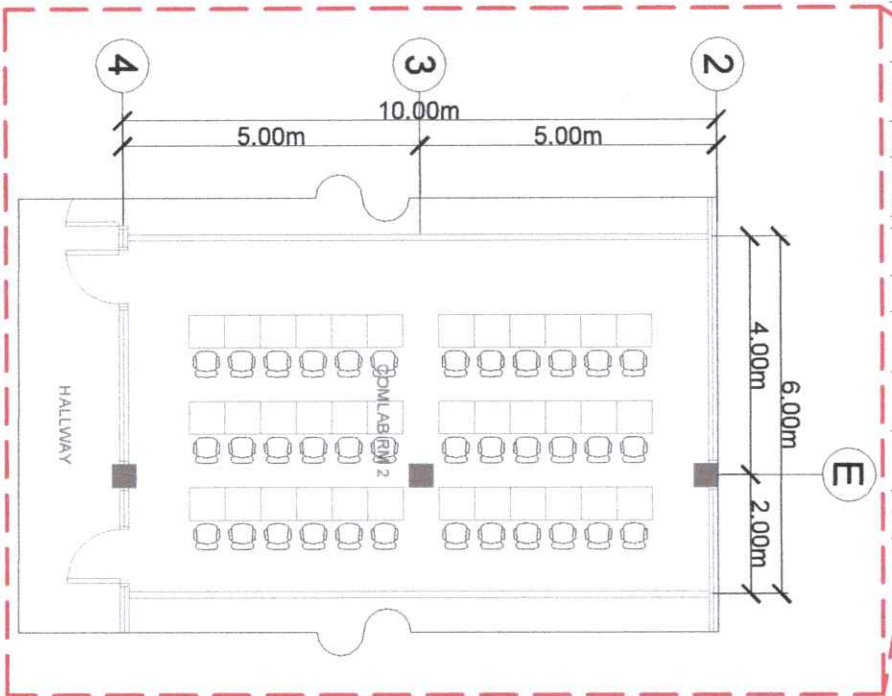
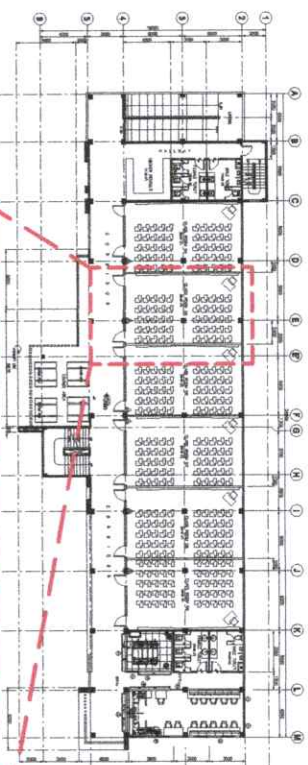


1 EXISTING FLOOR PLAN COM LAB 2, 2ND FLOOR STGB BUILDING
A03 SCALE: 1:120MTS

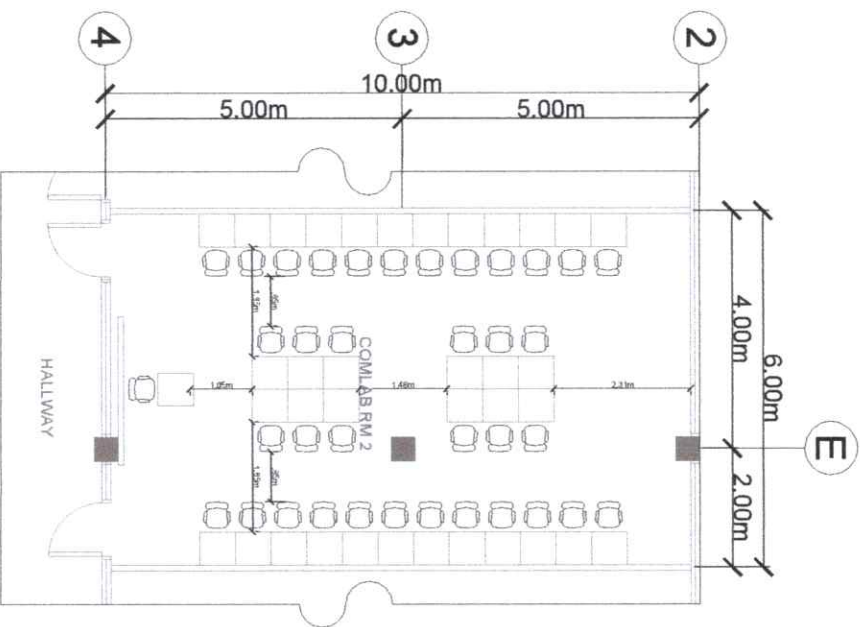


2 PROPOSED FLOOR PLAN COM LAB 2, 2ND FLOOR STGB BUILDING
A03 SCALE: 1:120MTS


 Republic of the Philippines CARLOS MILADO MEMORIAL STATE UNIVERSITY Negos Occidental Office of the Project Management Unit		PROJECT TITLE: REPAIR AND ENHANCEMENT OF THE COMPUTER LABORATORIES AT ALIIS CAMPUS		ENDORSED BY:  ENGR. JOE M. LOPEZ, RMD, RPE Chief Engineer, Aliis Campus		PREPARED BY:  ENGR. JONI A. BENAVIDEZ, RMD, RPE Assistant Engineer, Aliis Campus		CHECKED BY:  ENGR. JUN-JUN J. MARROQUE, RMD, RPE Assistant Engineer, Aliis Campus		RECOMMENDING APPROVAL:  ENGR. JUN-JUN J. MARROQUE, RMD, RPE Assistant Engineer, Aliis Campus		APPROVED BY:  NORBERTO P. MANGILI-BANAN, Ph.D. SUC President III		SHEET NO: A		PAGE NO: 3 / 6	
--	--	--	--	--	--	--	--	--	--	---	--	---	--	-------------	--	----------------	--

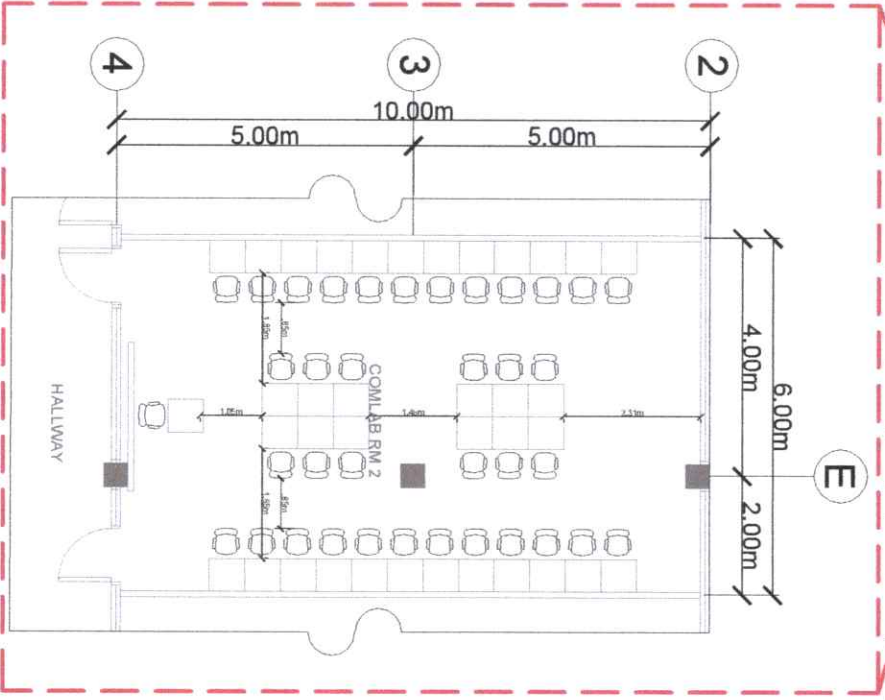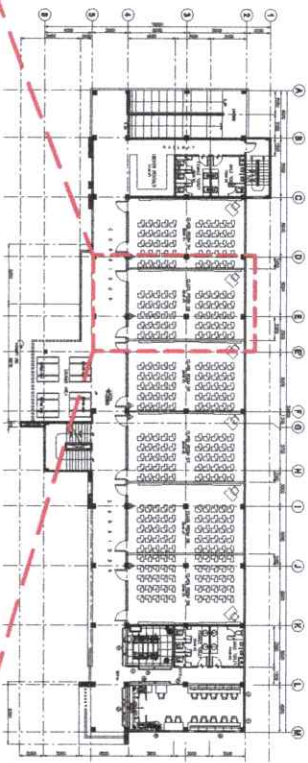

1 COMLAB 2 FLOOR PLAN 2ND FLOOR STGB BUILDING
SCALE: 1:120MTS

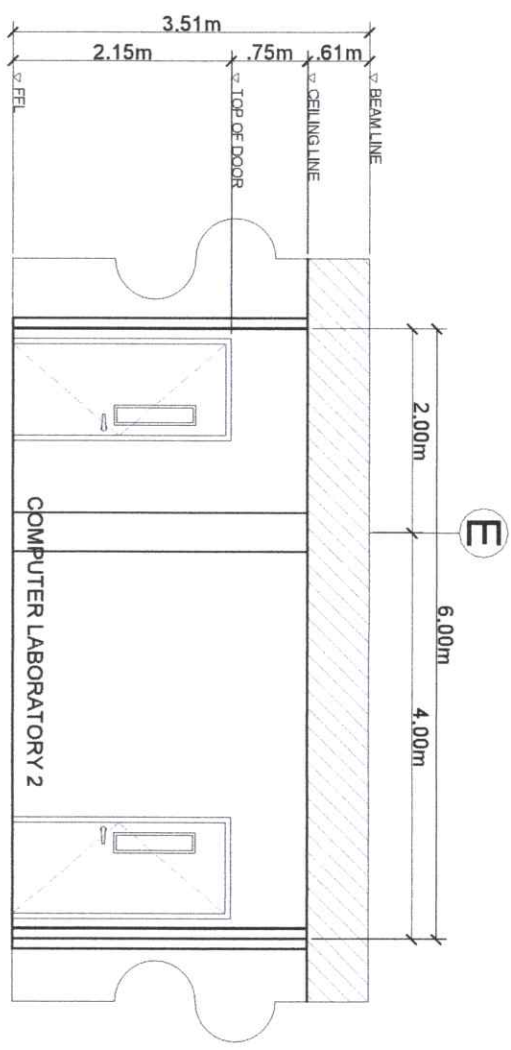



2 COMPUTER LABORATORY 2
SECTION THRU 'X-X'
SCALE: 1:70MTS

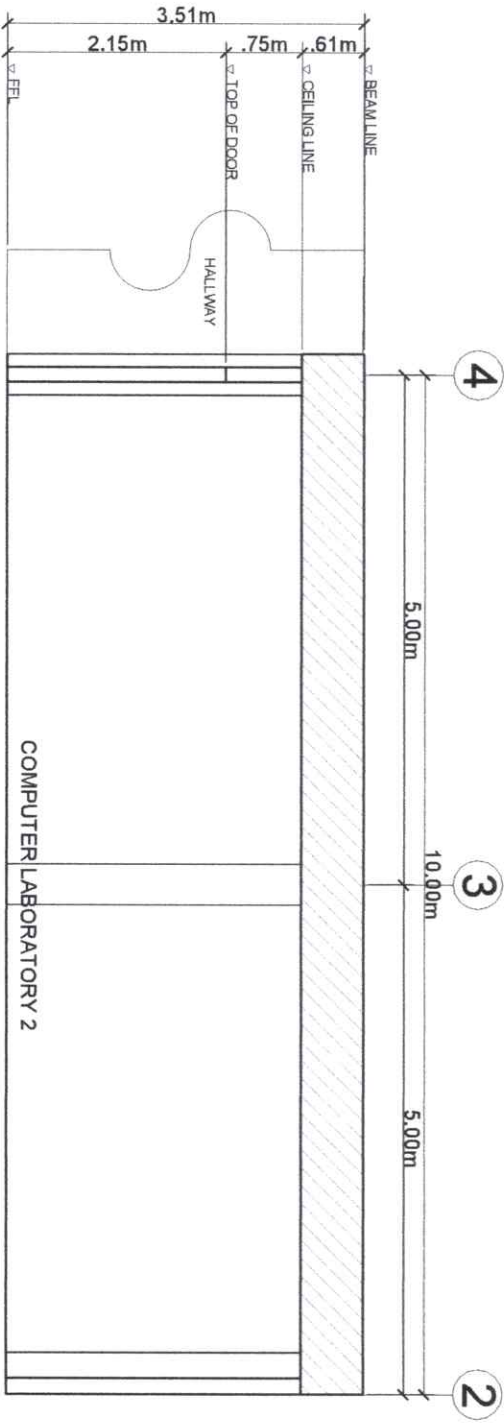


3 COMPUTER LABORATORY 2
SECTION THRU 'Y-Y'
SCALE: 1:70MTS

 Republic of the Philippines CALOCS RILADO MEMORIAL STATE UNIVERSITY Negros Occidental		PROJECT TITLE: REPAIR AND ENHANCEMENT OF THE COMPUTER LABORATORIES AT ALJIS CAMPUS		PROJECT LOCATION: ALJIS CAMPUS	
OFFICE OF THE PROJECT MANAGEMENT UNIT		ENDORSED BY: ENG. JOE MALE D. COMANDO, JR. UNIVERSITY / DISTRICT / PROV. / ALJIS CAMPUS GLEN PEREZ B. GARCIA, MS. DISTRICT DIRECTOR, ALJIS CAMPUS		PREPARED BY: AB. BENJAMIN B. BULLAY, UPD JOHN / ENHANCEMENT OFFICER II, MAU ENG. JOHN MARK B. BENAMIRA ADMIN. OFF. / PROJECT MANAGEMENT UNIT - ALJIS	
CHECKED BY: AB. BENJAMIN B. BULLAY, UPD JOHN / ENHANCEMENT OFFICER II, MAU ENG. JOHN MARK B. BENAMIRA ADMIN. OFF. / PROJECT MANAGEMENT UNIT - ALJIS		RECOMMENDING APPROVAL: ENR. JON-JUN J. MABRUELA DIRECTOR, PROJECT MANAGEMENT UNIT		APPROVED BY: JAY A. STRELLAS, EdD. VICE PRESIDENT FOR ADMINISTRATION AND FINANCE	
SHEET NO: A		PAGE NO: 4		6	

26-443

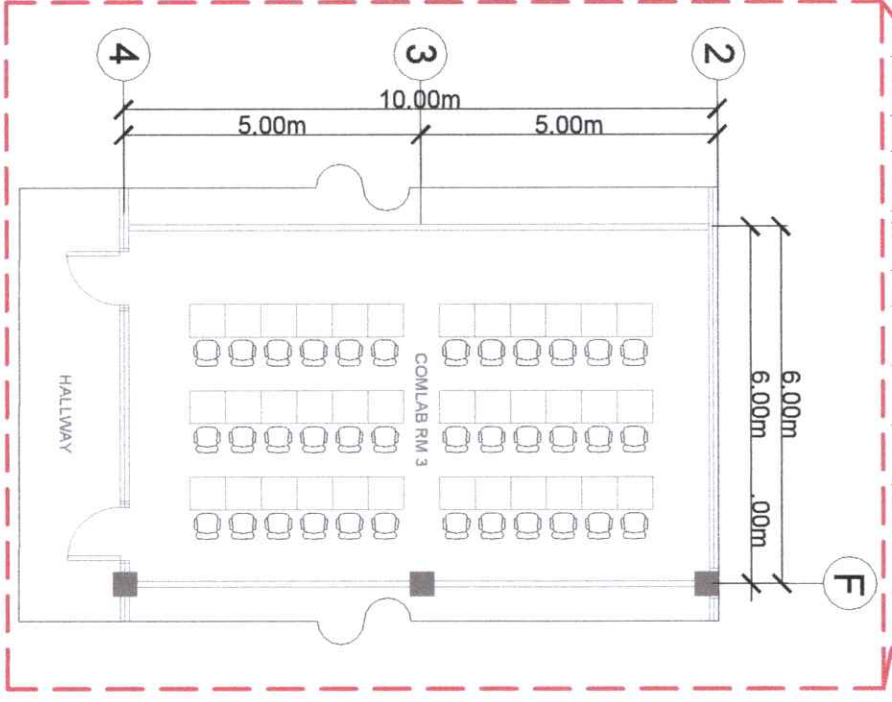
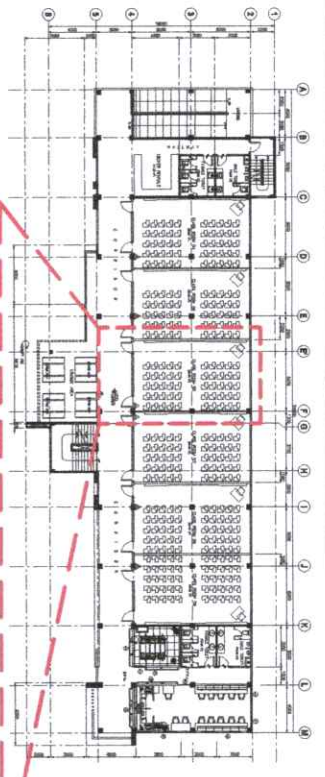


1 EXISTING FLOOR PLAN COM LAB 3, 2ND FLOOR STGB BUILDING
A05 SCALE: 1:120MTS


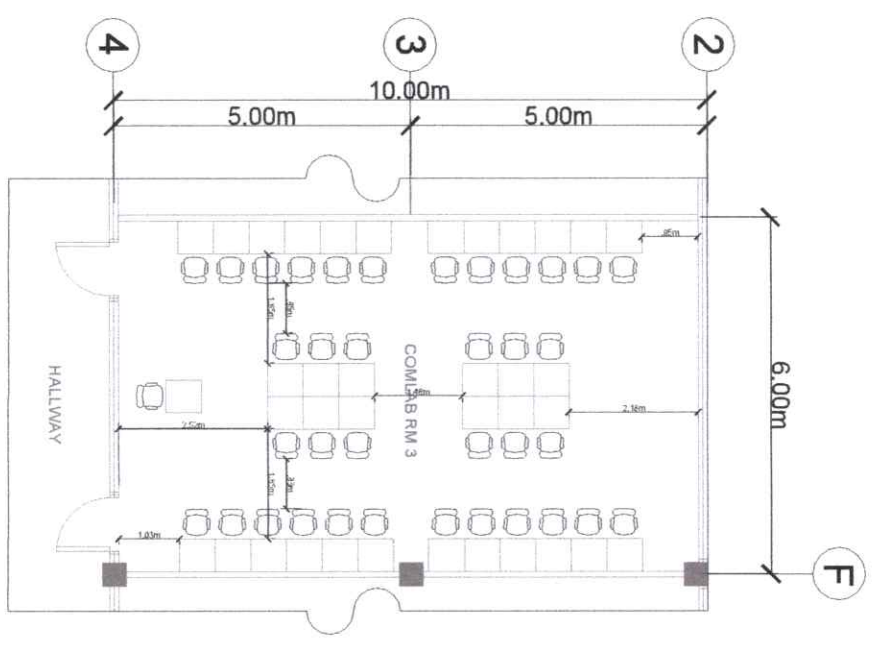


2 PROPOSED FLOOR PLAN COM LAB 3, 2ND FLOOR STGB BUILDING
A05 SCALE: 1:120MTS

Republic of the Philippines CARAGA MINDANAO STATE UNIVERSITY Negros Occidental	
PROJECT TITLE: REPAIR AND ENHANCEMENT OF THE COMPUTER LABORATORIES AT ALIJS CAMPUS	
ENDORSED BY: 	PREPARED BY:
ENGR. JOE MARK D. BENAVENTE Engr., Civil Engineering, USTP ALIJOS CAMPUS	ENGR. JOE MARK D. BENAVENTE Engr., Civil Engineering, USTP ALIJOS CAMPUS
GLEN PEREZ, GARCIA, MS. EXECUTIVE DIRECTOR, ALIJOS CAMPUS	ENGR. JOE MARK B. BENAVENTE Engr., Civil Engineering, USTP ALIJOS CAMPUS
CHECKED BY: 	RECOMMENDING APPROVAL:
ENGR. JOE MARK D. BENAVENTE Engr., Civil Engineering, USTP ALIJOS CAMPUS	ENGR. JOE MARK D. BENAVENTE Engr., Civil Engineering, USTP ALIJOS CAMPUS
APPROVED BY: 	SHEET NO: A
NORBERTO P. MANGULABNAN, Ph.D. SUC PRESIDENT III	PAGE NO: 5

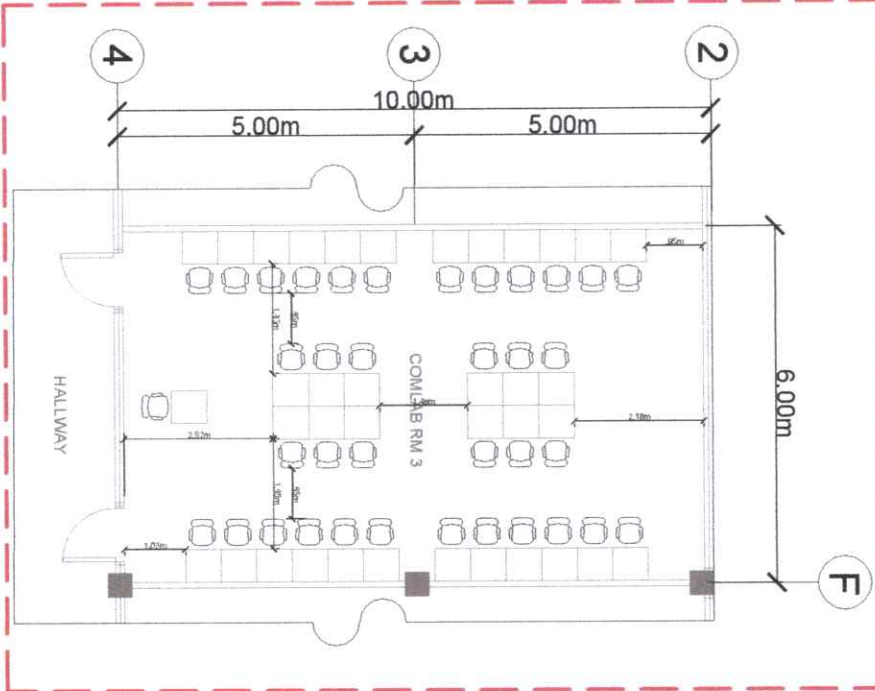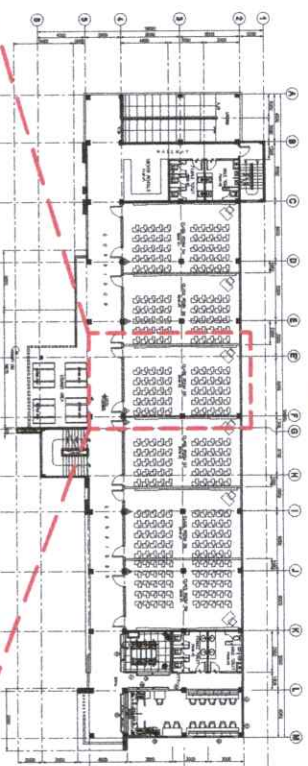



1 COMLAB 3 FLOOR PLAN 2ND FLOOR STGB BUILDING
A06 SCALE: 1:120MTS

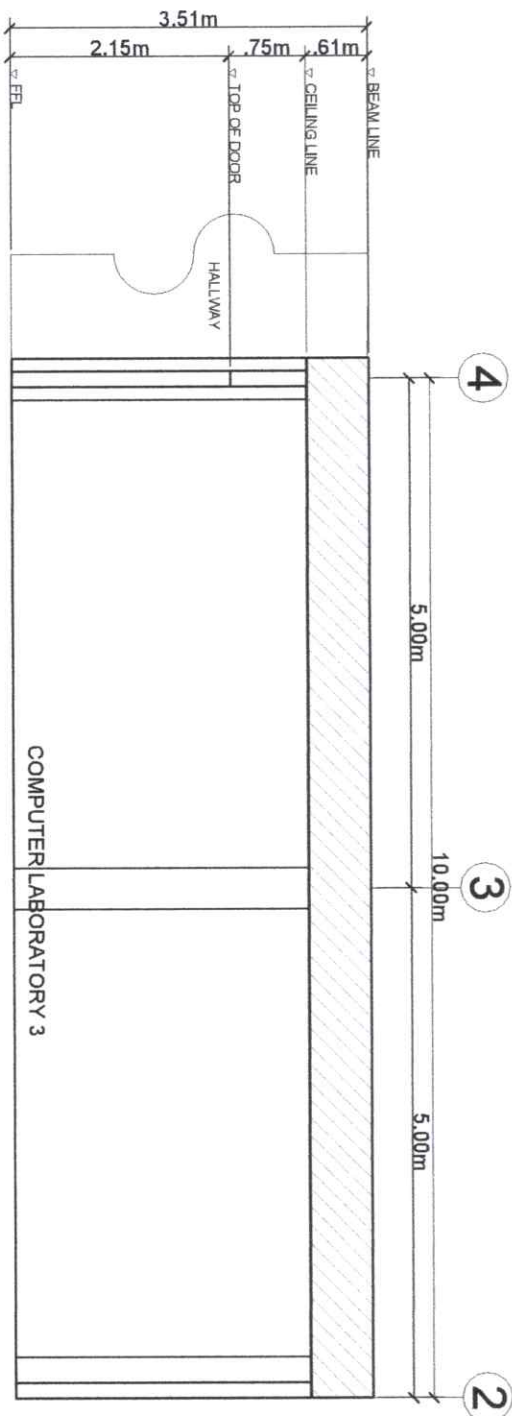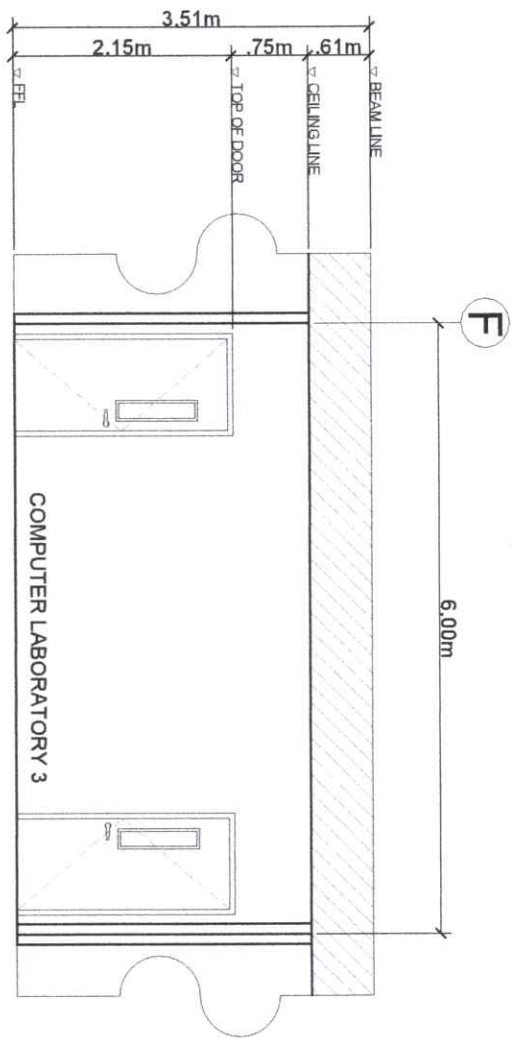

2 SECTION THRU 'X-X'
A06 SCALE: 1:70MTS

3 SECTION THRU 'Y-Y'
A06 SCALE: 1:70MTS

 Republic of the Philippines CARLOS MIAO MEMORIAL STATE UNIVERSITY Negos Occidental	PROJECT TITLE:	ENDORSED BY:	PREPARED BY:	CHECKED BY:	RECOMMENDING APPROVAL:	APPROVED BY:	SHEET NO:	PAGE NO:
	REPAIR AND ENHANCEMENT OF THE COMPUTER LABORATORIES AT ALIIS CAMPUS PROJECT LOCATION: ALIIS CAMPUS	ENGR. JOE MARI B. JACINTO, DIT ALYAN, CO-ORDINATOR GLEN PEEA, SCACT, MS. EXECUTIVE DIRECTOR, ALIIS CAMPUS	FRANCINE G. JUAN UNIVERSITY GRAD. IN ENG. ALIIS CAMPUS ENGR. JOSE MARK B. BENAMIRA ADMIN. OFFICER, ALIIS CAMPUS PROJECT DEVELOPMENT OFFICER, ALIIS	AR. JANE M. BUSTOS, UGP TRACER DEVELOPMENT OFFICER, ALIIS ENGR. JONAS M. LAVEZ PROJECT DEVELOPMENT OFFICER, ALIIS	ENGR. JIM J. MARQUEZ DIRECTOR, PROJECT MANAGEMENT UNIT	JAY B. ESPINILLAS, EDD. VICE PRESIDENT FOR ADMINISTRATION FINANCE	NORBERTO P. MANGUABANAN, Ph.D. SVC PRESIDENT III	A

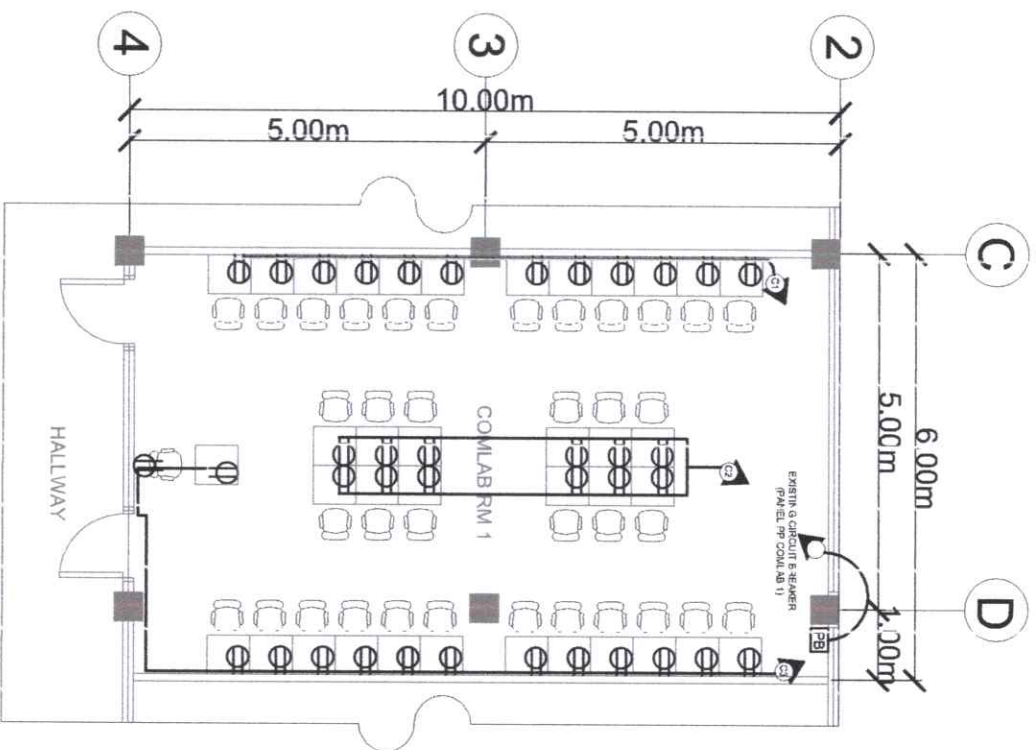
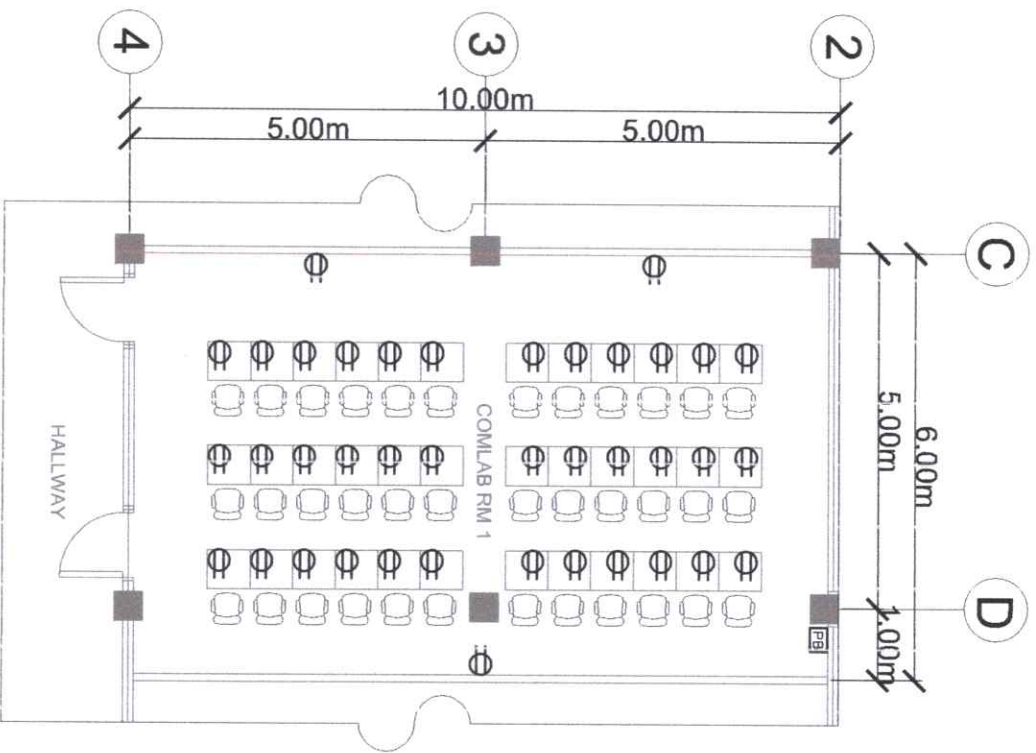


1 EXISTING COMLAB 1 POWER LAY-OUT
 E01 SCALE: 1:120M'S


2 PROPOSED COMLAB 1 POWER LAY-OUT
 E01 SCALE: 1:120M'S

 Republic of the Philippines CARLOS HILADO MEMORIAL STATE UNIVERSITY Negros Occidental		PROJECT TITLE: REPAIR AND ENHANCEMENT OF THE COMPUTER LABORATORIES AT ALIBIS CAMPUS	
ENDORSED BY:  ENGR. JOE MARIE J. DELGADO, DIT CHIEF OF OFFICE OF THE UNIVERSITY OF ALIBIS CAMPUS		PREPARED BY:  ENGR. JAY B. ESTRELLA, EED CHIEF OF OFFICE OF THE PROJECT MANAGEMENT UNIT	
CHECKED BY:  ENGR. PANTILO DESGUIRADO, PEE PROJECT DEVELOPMENT OFFICER		RECOMMENDING APPROVAL:  ENGR. JUN-JUN J. ARCE CHIEF OF OFFICE OF THE PROJECT MANAGEMENT UNIT	
APPROVED BY:  NORBERTO P. MANQUILANAN, Ph.D. SUC PRESIDENT III		SHEET NO: E PAGE NO: 14	


26-443

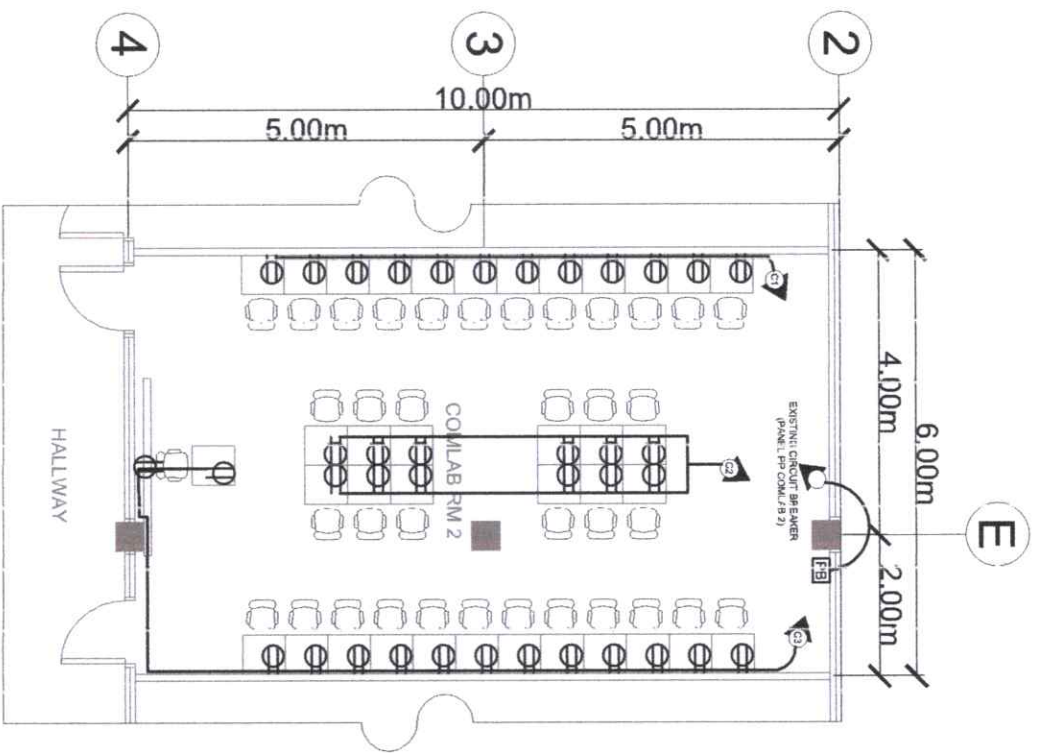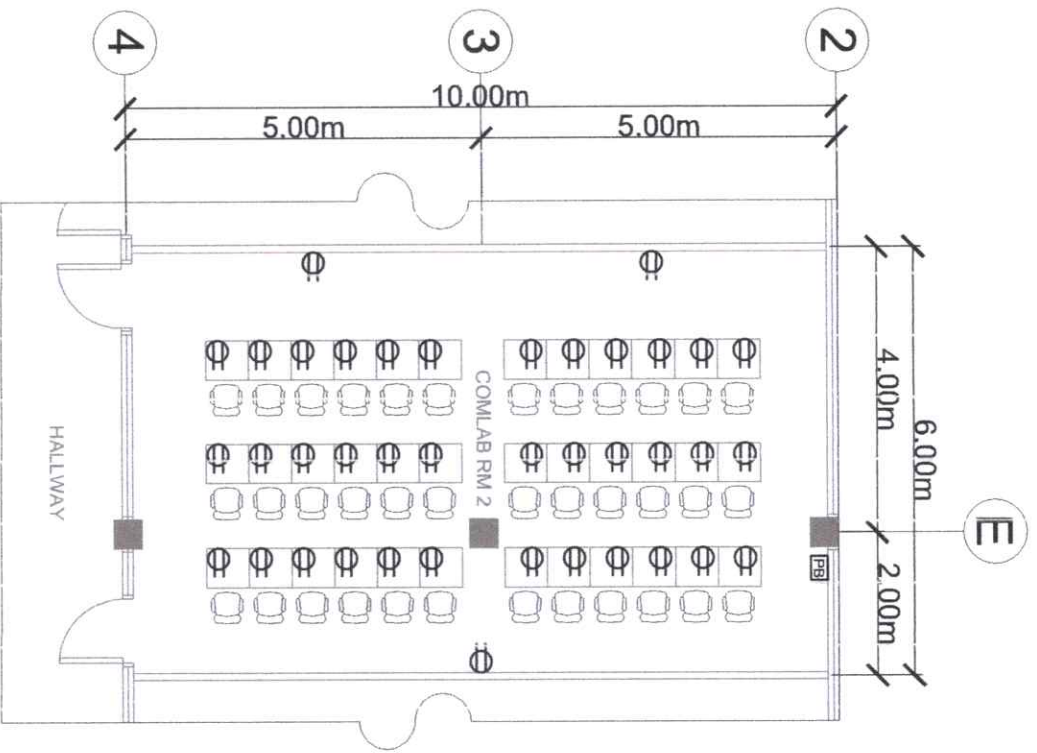




 Republic of the Philippines CARLOS MILADO MEMORIAL STATE UNIVERSITY Negros Occidental		PROJECT TITLE: REPAIR AND ENHANCEMENT OF THE COMPUTER LABORATORIES AT ALIBIS CAMPUS		ENDORSED BY: ENGR. JOE MARE B. DO AMOR UNIVERSITY ASSISTANT PROFESSOR COMPUTER LABORATORIES - ALIBIS CAMPUS		PREPARED BY: FRANCISCO G. PANTILLO UNIVERSITY ASSISTANT PROFESSOR COMPUTER LABORATORIES - ALIBIS CAMPUS		CHECKED BY: ENGR. PANTILLO DESQUIRADO, PEE PROJECT MANAGER OFFICE - ALIBIS		RECOMMENDING APPROVAL: ENGR. JUN-JUN J. MARGUEDA DIRECTOR, PROJECT MANAGEMENT UNIT		APPROVED BY: JAY B. ESTRELLAS, EDD. VICE PRESIDENT FOR ADMINISTRATION		SHEET NO.: E		PAGE NO.: 24	
OFFICE OF THE PROJECT MANAGEMENT UNIT		PROJECT LOCATION: ALIBIS CAMPUS		EXECUTIVE DIRECTOR: ALIBIS CAMPUS		ADMIN. OFFICER: PROJECT MANAGEMENT UNIT - ALIBIS		PROJECT PRECOORDINATING OFFICER: ALIBIS									

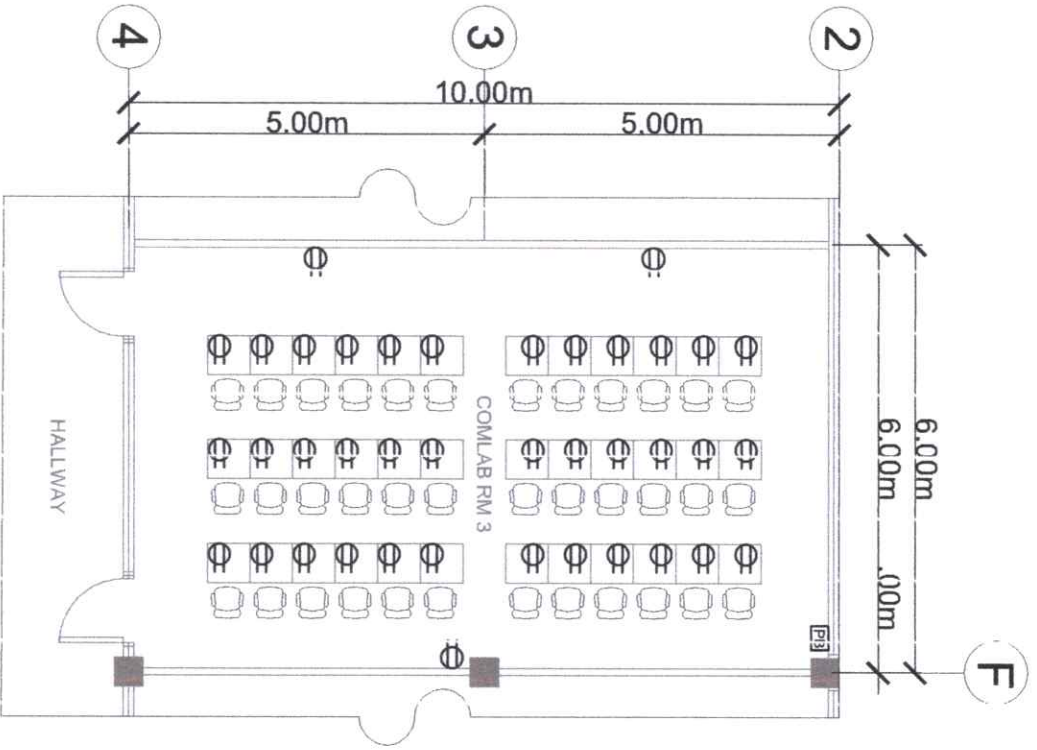


1 EXISTING COMLAB 3 POWER LAY-OUT
 E03 SCALE: 1:120M/TS

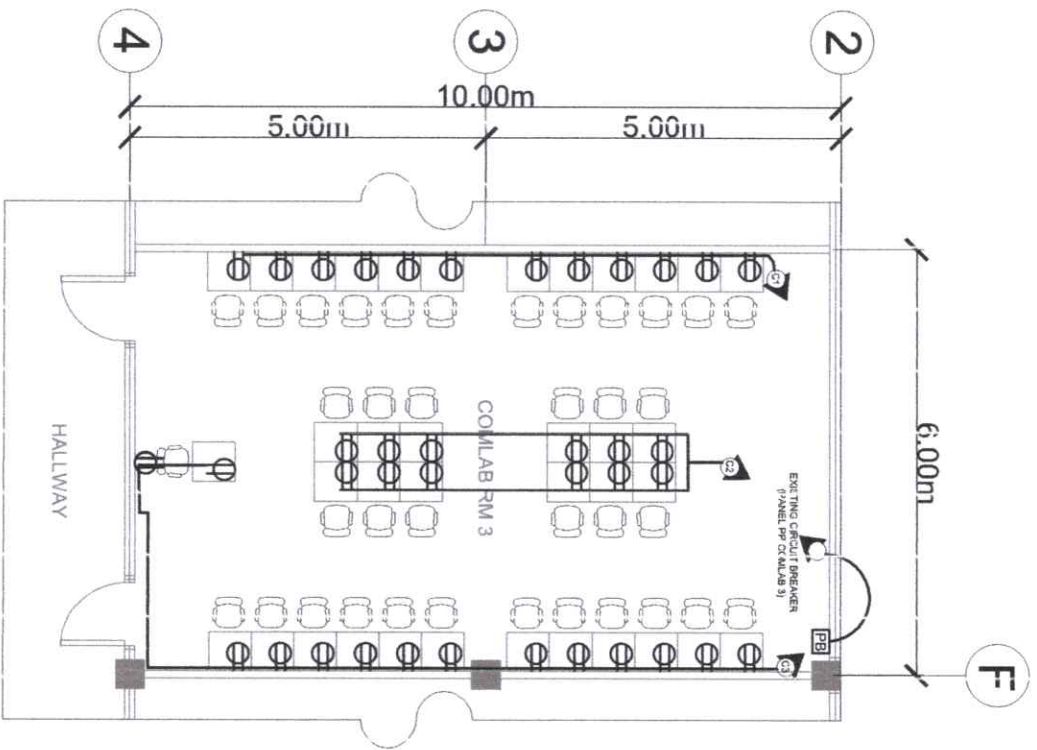

2 PROPOSED COMLAB 3 POWER LAY-OUT
 E03 SCALE: 1:120M/TS

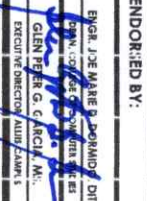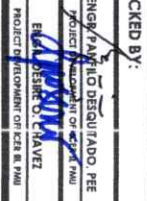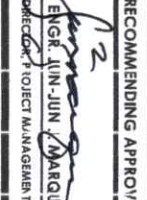 Republic of the Philippines CARLOS HILADO A. RAMONAL 3 ARE UNIVERSITY Negros Occidental		PROJECT TITLE: REPAIR AND ENHANCEMENT OF THE COMPUTER LABORATORIES AT ALIIS CAMPUS	
ENDORSED BY: ENGR. JOE MARE B. DE RAMOS, DIT DEAN, COLLEGE OF ENGINEERING AND TECHNOLOGY, 3 ARE UNIVERSITY ALIIS CAMPUS, NEGROS OCCIDENTAL 		PREPARED BY: ENGR. JONATHAN B. JIN UNIVERSITY ASSISTANT III, ALIIS CAMPUS 	
CHECKED BY: ENGR. FAYALDO DESOUZADO, PEE PROJECT MANAGER OF 3 ARE 		RECOMMENDING APPROVAL: ENGR. JIN JIN MARQUEZ DIRECTOR, PROJECT MANAGEMENT UNIT 	
APPROVED BY: NORBERTO P. MANGUABANAN, Ph.D SUC PRESIDENT III 		SHEET NO.: E	
PAGE NO.: 3		PAGE NO.: 4	

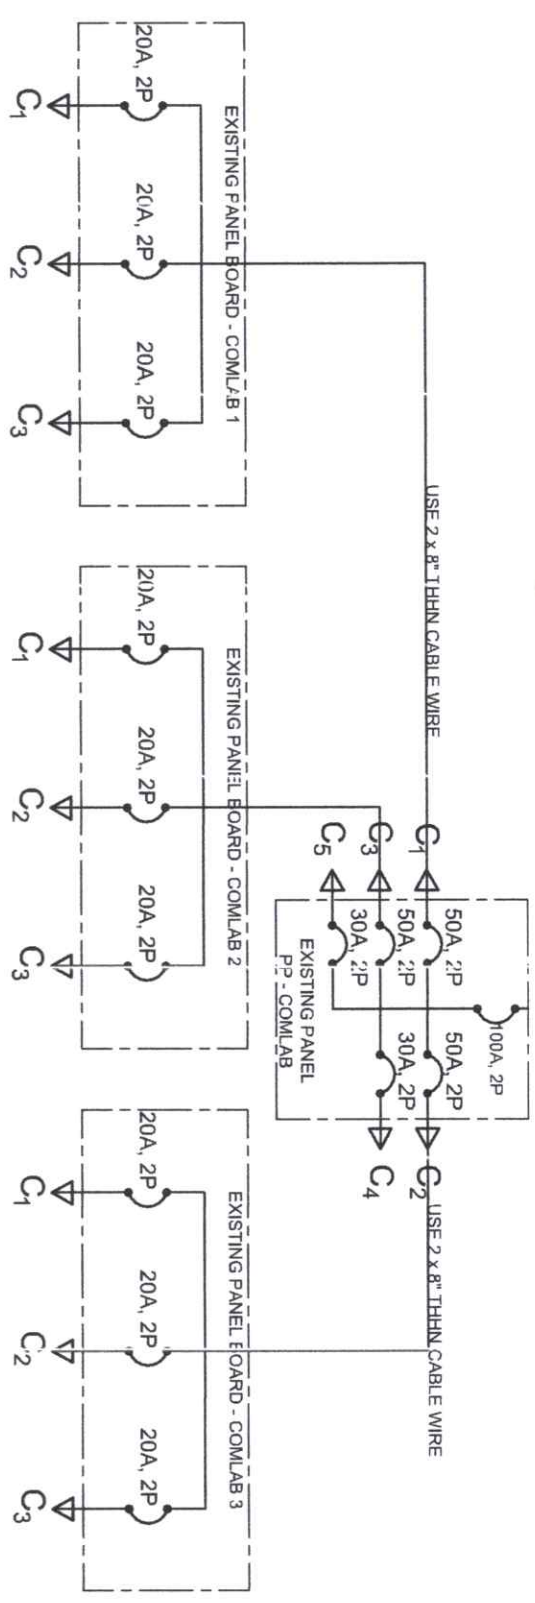

1 SINGLE LINE DIAGRAM
E04 SCALE: NDTs

PANEL BOARD NAME: PP COMLAB 1									
CKT NO.	LOAD DESCRIPTION	NO. OF OUTLET	VA	RATED AMPERE	CIRCUIT BREAKER			CABLE SIZE	CONDUIT SIZE
					POLE	AT	AF	TYPE	KAIC
C1	12 - TWO GANG CONVENIENCE OUTLET	12	3600	16.363636	1	20	50	MCB	5
C2	12 - TWO GANG CONVENIENCE OUTLET	12	3600	16.363636	1	20	50	MCB	5
C3	14 - TWO GANG CONVENIENCE OUTLET	14	4200	19.090909	1	20	50	MCB	5
		TOTAL	11400	51.818182					

PANEL BOARD NAME: PP COMLAB 2									
CKT NO.	LOAD DESCRIPTION	NO. OF OUTLET	VA	RATED AMPERE	CIRCUIT BREAKER			CABLE SIZE	CONDUIT SIZE
					POLE	AT	AF	TYPE	KAIC
C1	12 - TWO GANG CONVENIENCE OUTLET	12	3600	16.363636	1	20	50	MCB	5
C2	12 - TWO GANG CONVENIENCE OUTLET	12	3600	16.363636	1	20	50	MCB	5
C3	14 - TWO GANG CONVENIENCE OUTLET	14	4200	19.090909	1	20	50	MCB	5
		TOTAL	11400	51.818182					

PANEL BOARD NAME: PP COMLAB 3									
CKT NO.	LOAD DESCRIPTION	NO. OF OUTLET	VA	RATED AMPERE	CIRCUIT BREAKER			CABLE SIZE	CONDUIT SIZE
					POLE	AT	AF	TYPE	KAIC
C1	12 - TWO GANG CONVENIENCE OUTLET	12	3600	16.363636	1	20	50	MCB	5
C2	12 - TWO GANG CONVENIENCE OUTLET	12	3600	16.363636	1	20	50	MCB	5
C3	14 - TWO GANG CONVENIENCE OUTLET	14	4200	19.090909	1	20	50	MCB	5
		TOTAL	11400	51.818182					

PANEL BOARD NAME: PP COMLAB 3									
CKT NO.	LOAD DESCRIPTION	NO. OF OUTLET	VA	RATED AMPERE	CIRCUIT BREAKER			CABLE SIZE	CONDUIT SIZE
					POLE	AT	AF	TYPE	KAIC
C1	12 - TWO GANG CONVENIENCE OUTLET	12	3600	16.363636	1	20	50	MCB	5
C2	12 - TWO GANG CONVENIENCE OUTLET	12	3600	16.363636	1	20	50	MCB	5
C3	14 - TWO GANG CONVENIENCE OUTLET	14	4200	19.090909	1	20	50	MCB	5
		TOTAL	11400	51.818182					

2 SCHEDULE OF LOADS
E04 SCALE: NDTs



Republic of the Philippines
CARLOS HILADO A. REMOLAL
STATE UNIVERSITY
Negros Occidental

PROJECT TITLE: REPAIR AND ENLARGEMENT OF THE COMPUTER LABORATORIES AT ALIUS CAMPUS

PROJECT LOCATION: ALIUS CAMPUS

ENGINEERED BY: ENGR. JOE MARIE B. DELA CRUZ, DIT

PREPARED BY: ENGR. JOSE MARIE B. DELA CRUZ, DIT

CHECKED BY: ENGR. JOSE MARIE B. DELA CRUZ, DIT

RECOMMENDING APPROVAL: ENGR. JOSE MARIE B. DELA CRUZ, DIT

APPROVED BY: ENGR. JOSE MARIE B. DELA CRUZ, DIT

OFFICE OF THE PROJECT MANAGER/IN-CHARGE

PROJECT MANAGER/IN-CHARGE

ENGR. JOSE MARIE B. DELA CRUZ, DIT

ENGR. JOSE MARIE B. DELA CRUZ, DIT

ENGR. JOSE MARIE B. DELA CRUZ, DIT

SHEET NO: E

PAGE NO: 4